


特記事項


图二 町民体育館新築工事

1/100


1984

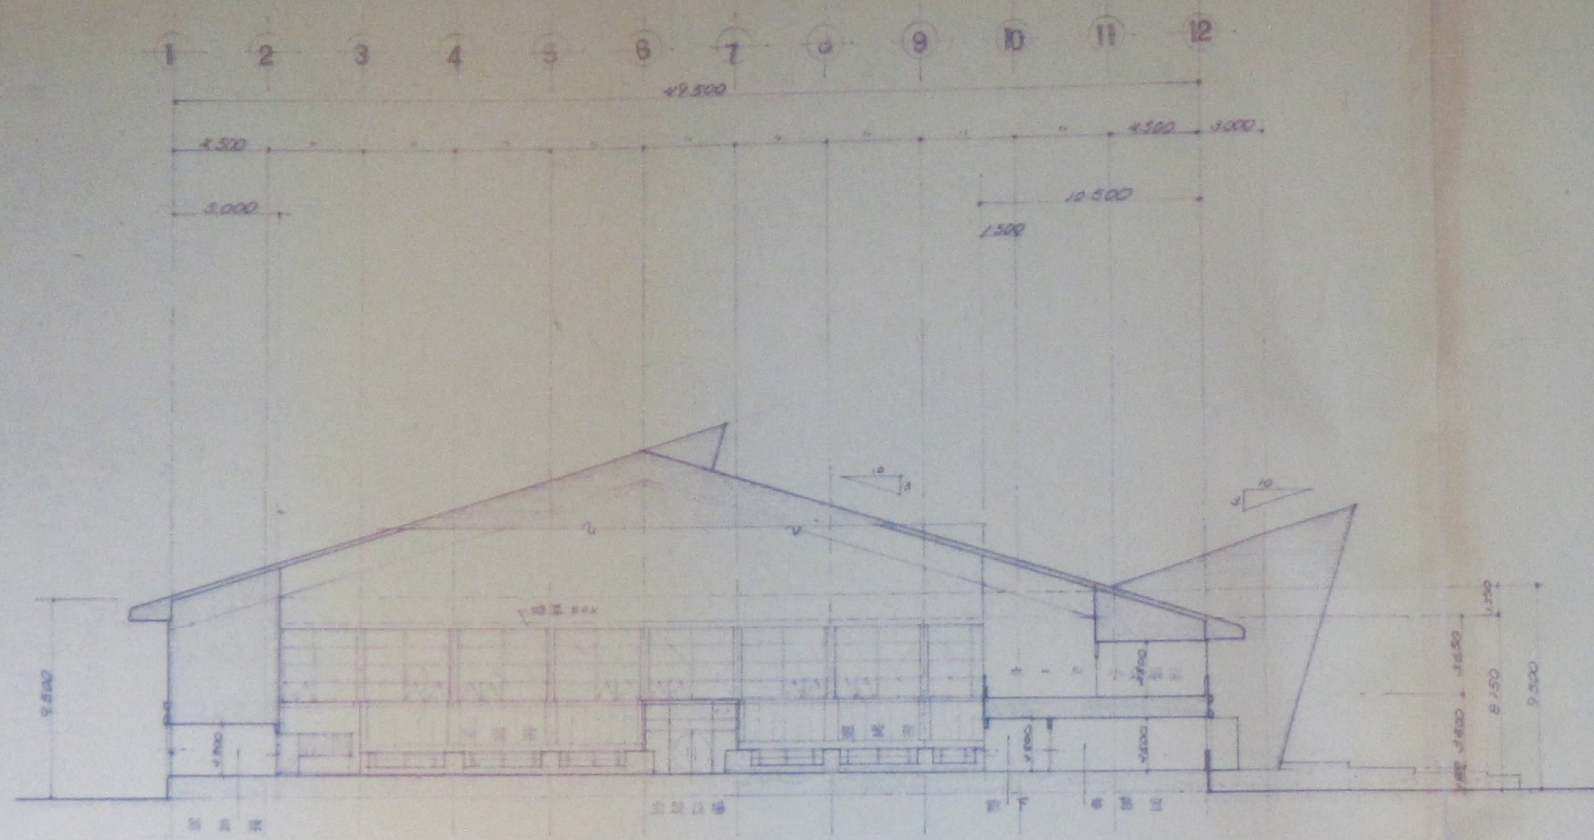


1-12 斷面圖 SCALE 1:125

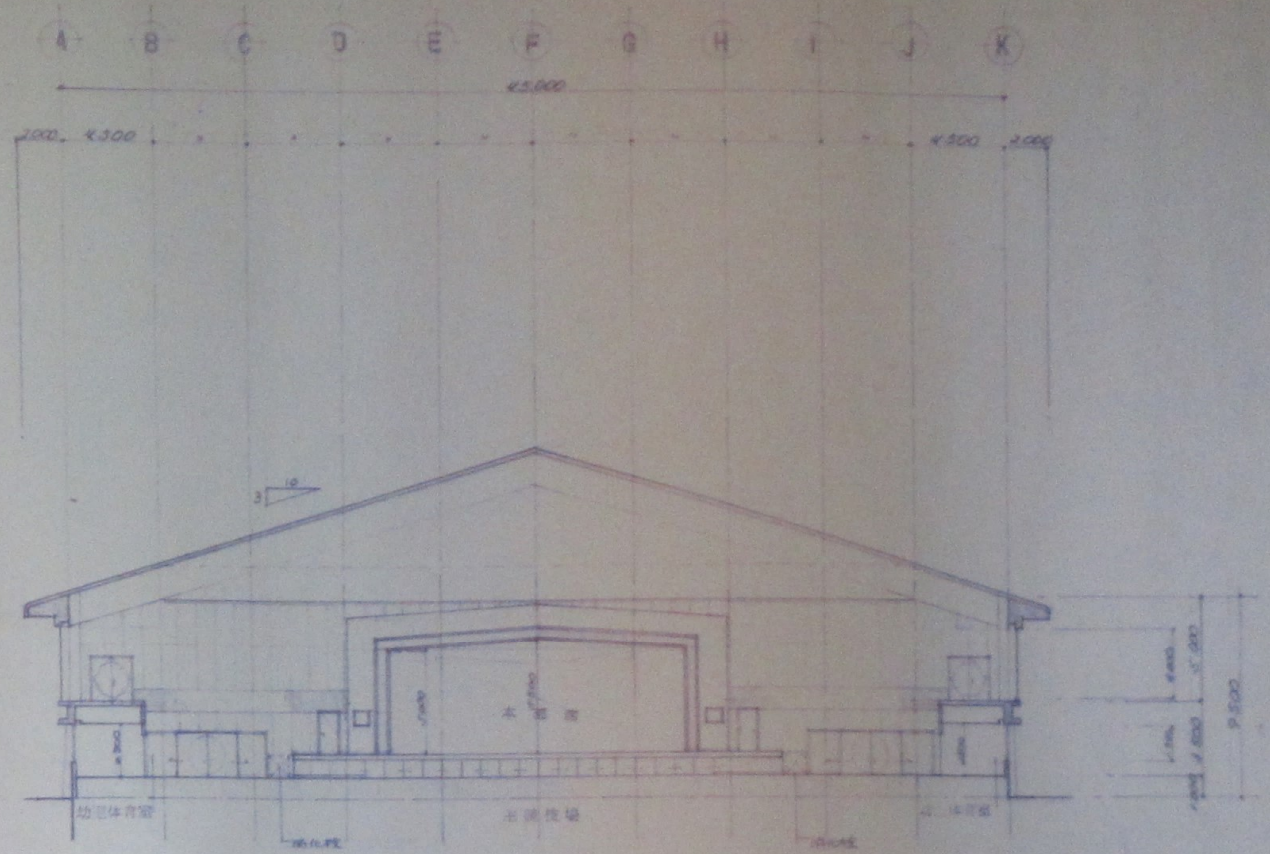

A-K 斷面圖 SCALE 1:125

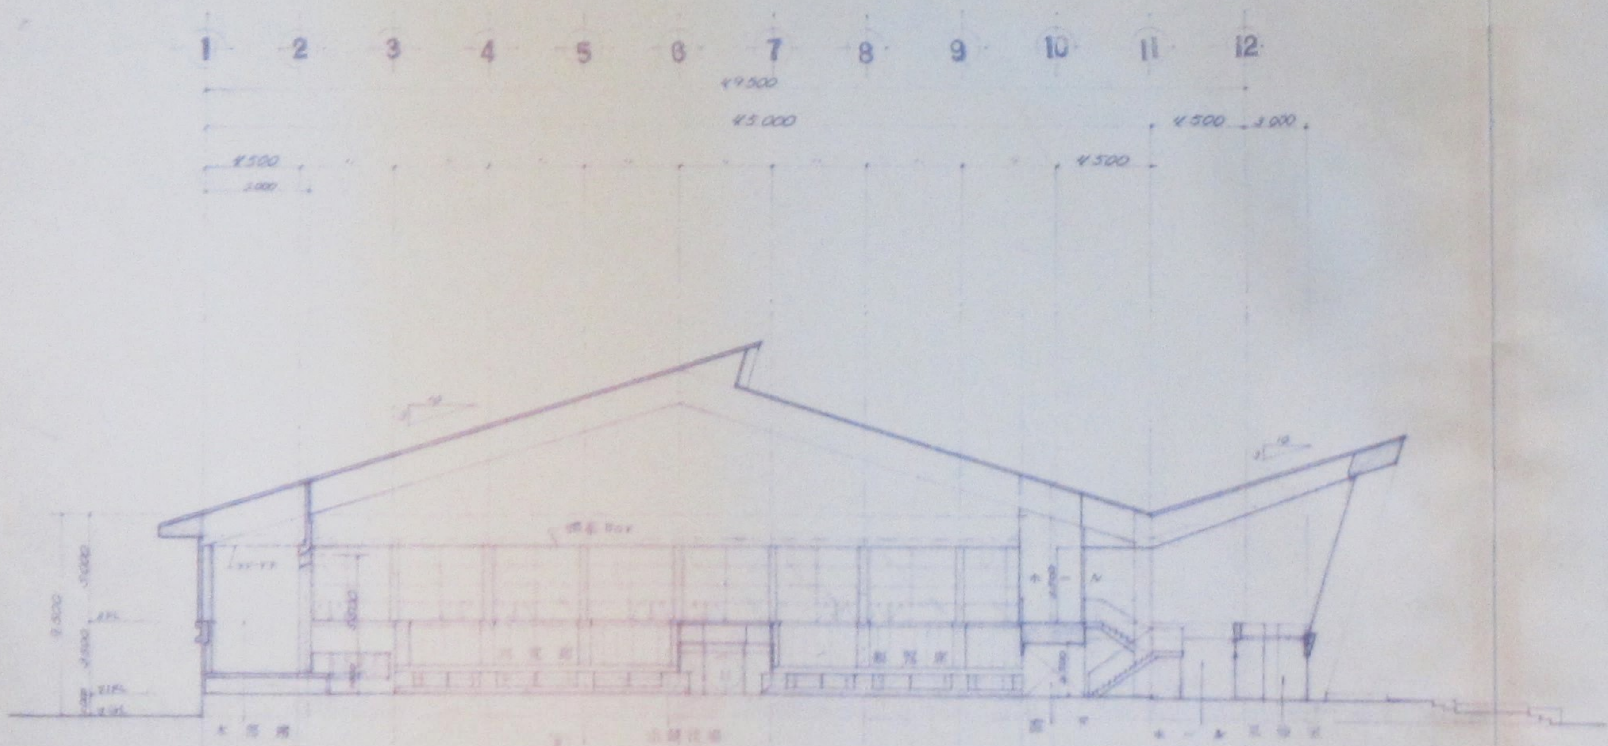

1-12 斷面圖 SCALE 1:125

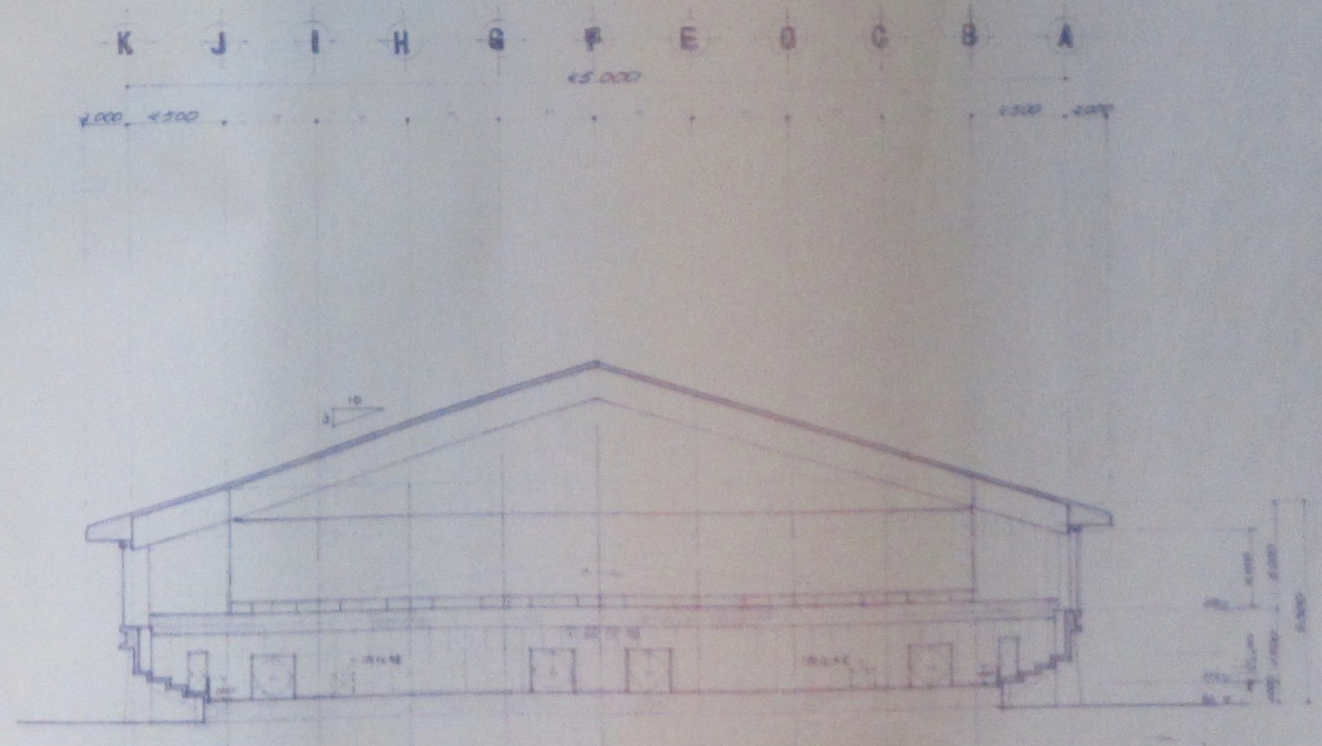

A-K 斷面圖 SCALE 1:125

特記事項


設計名稱

百石町民體育館新築工事






設計者



設計日期





斷面圖

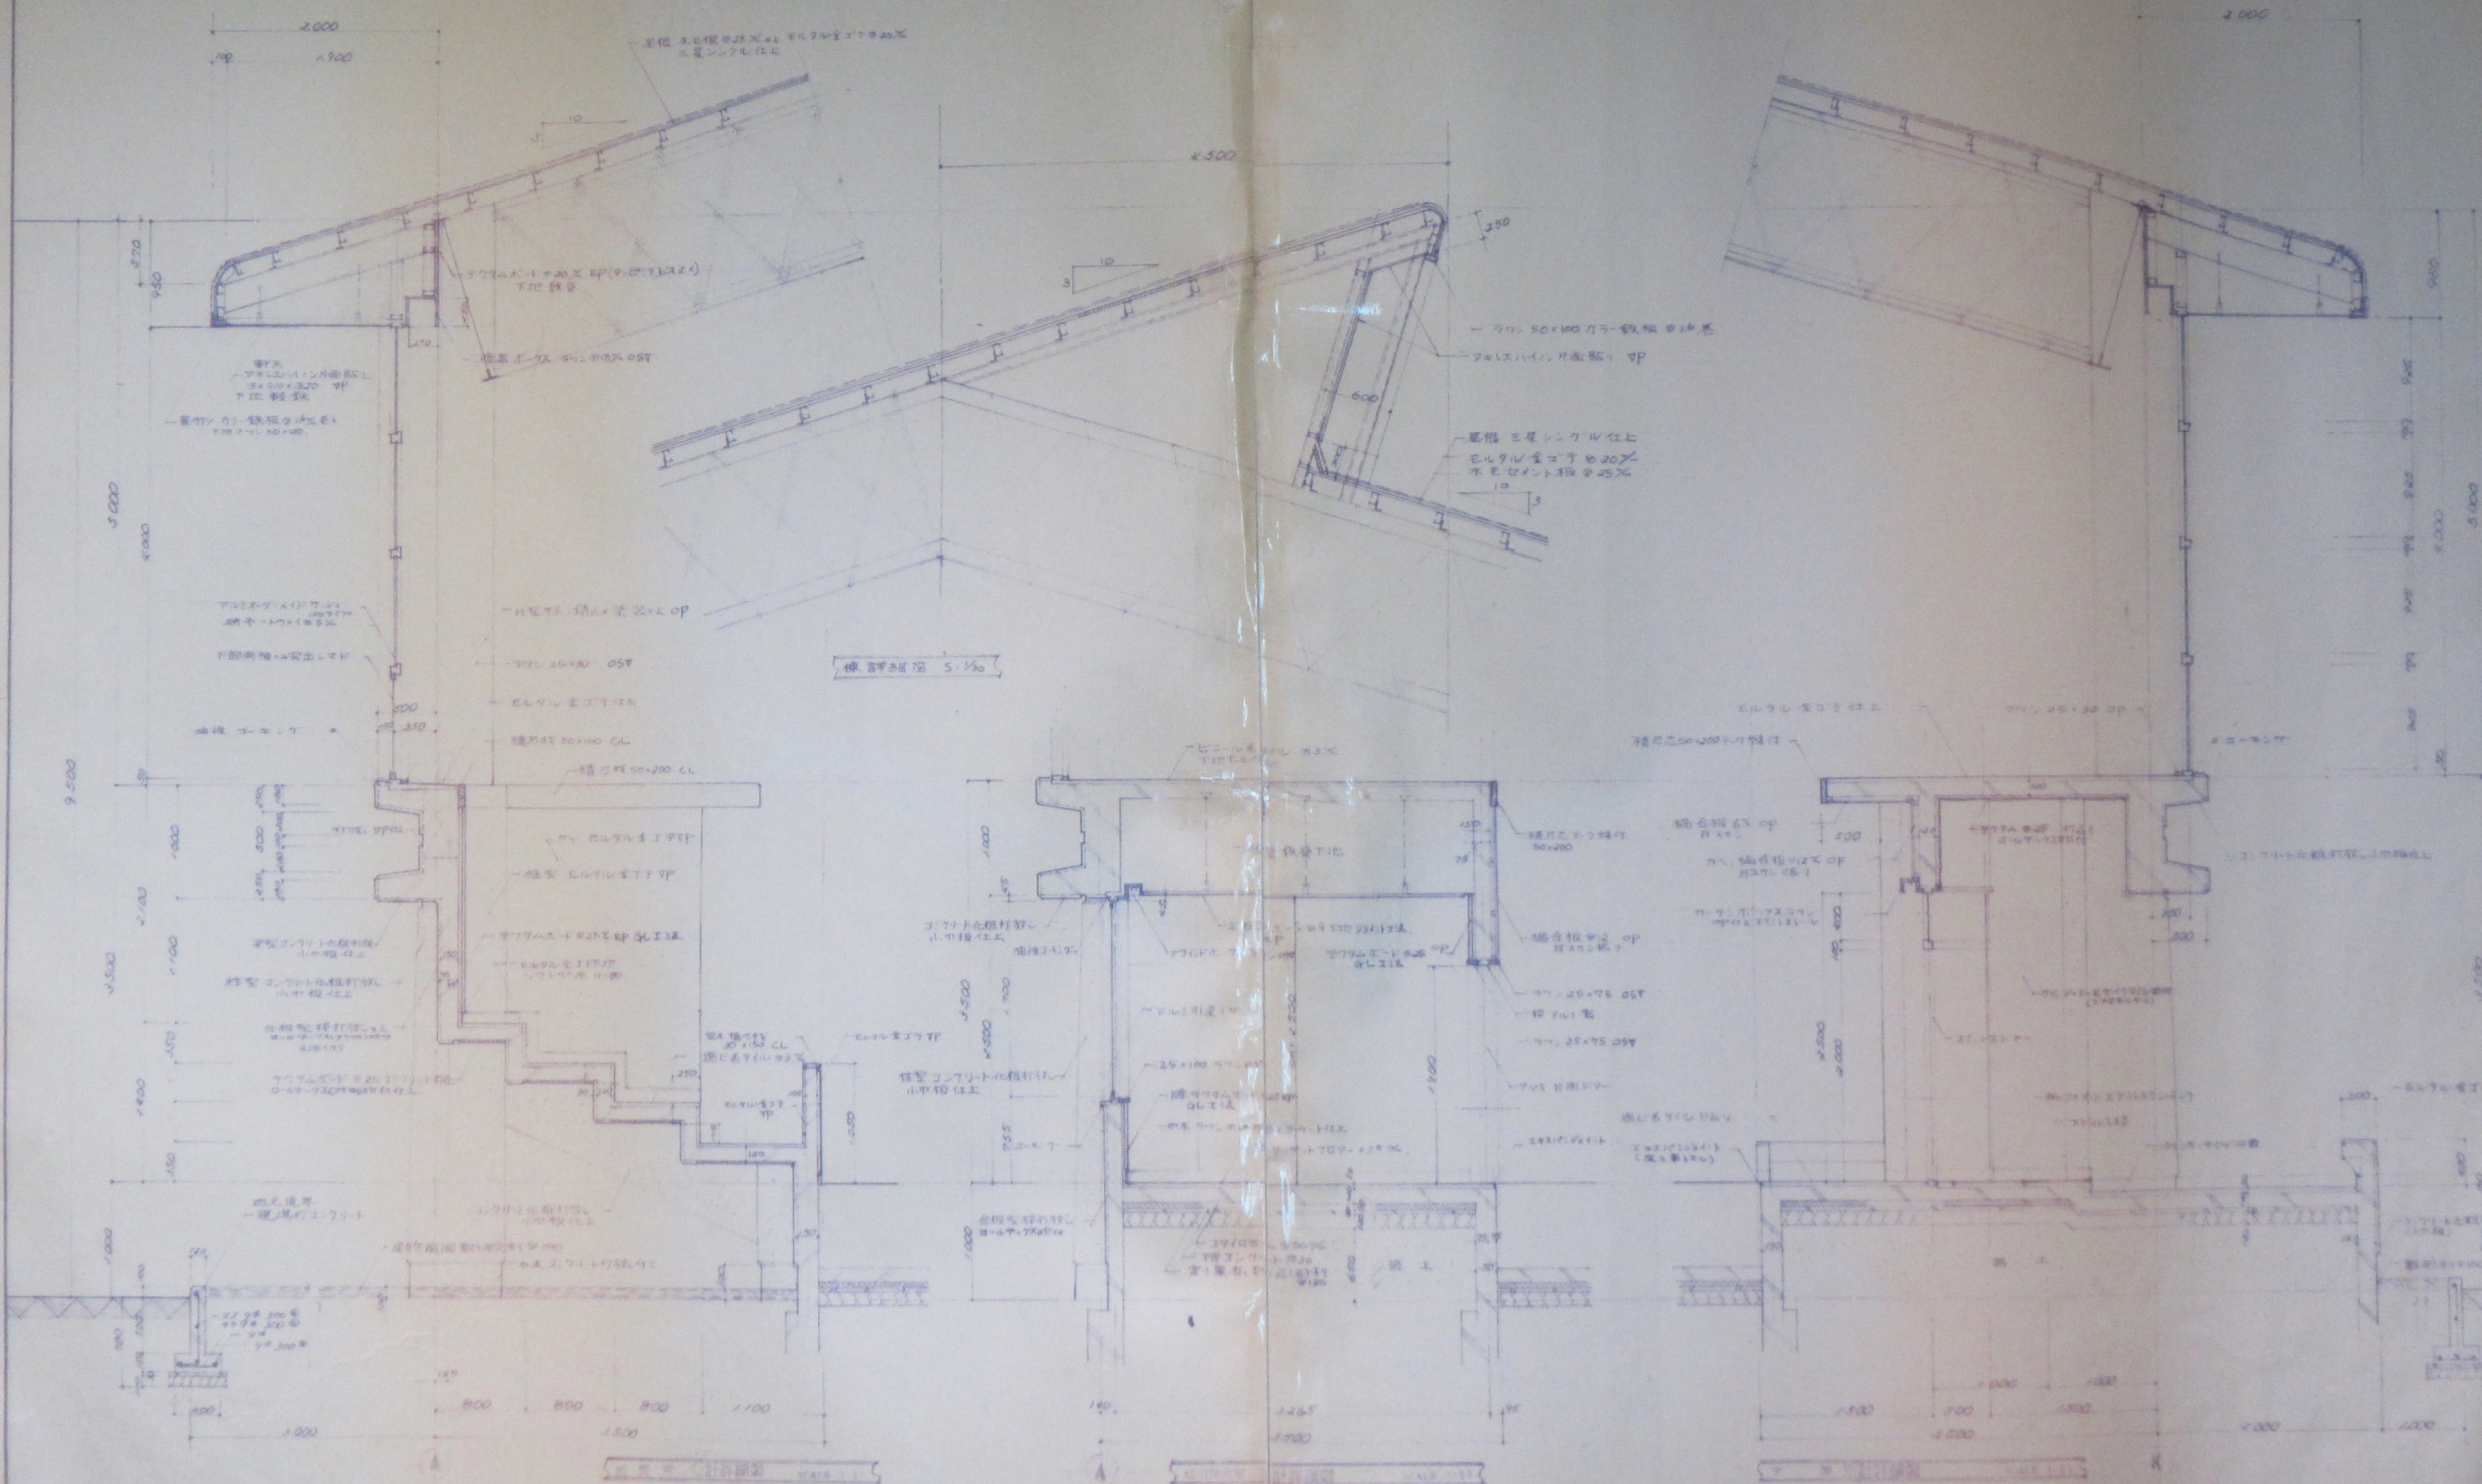


<p>特記事項</p>	<p>昭和 年 月 日</p>	<p>(記事)</p>	<p>設計名称 石町民体育館新築工事 設計者 製図 図面名称 縮尺 図面番号</p>
-------------	-----------------	-------------	---

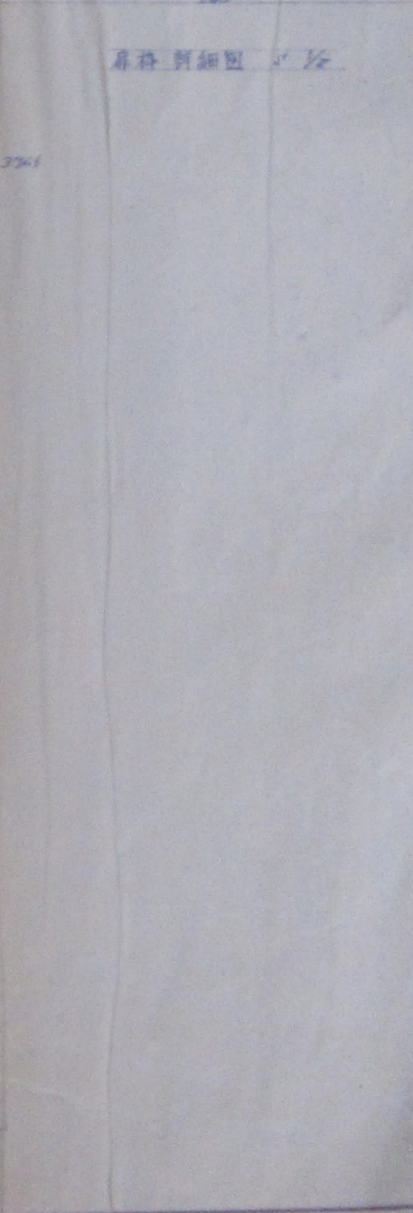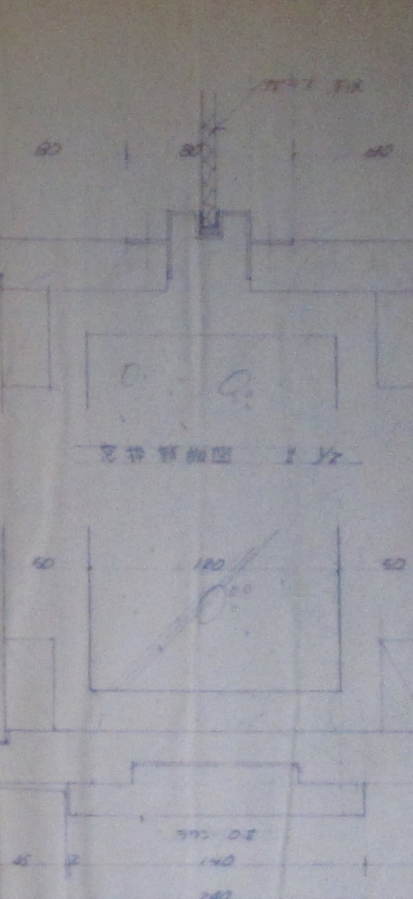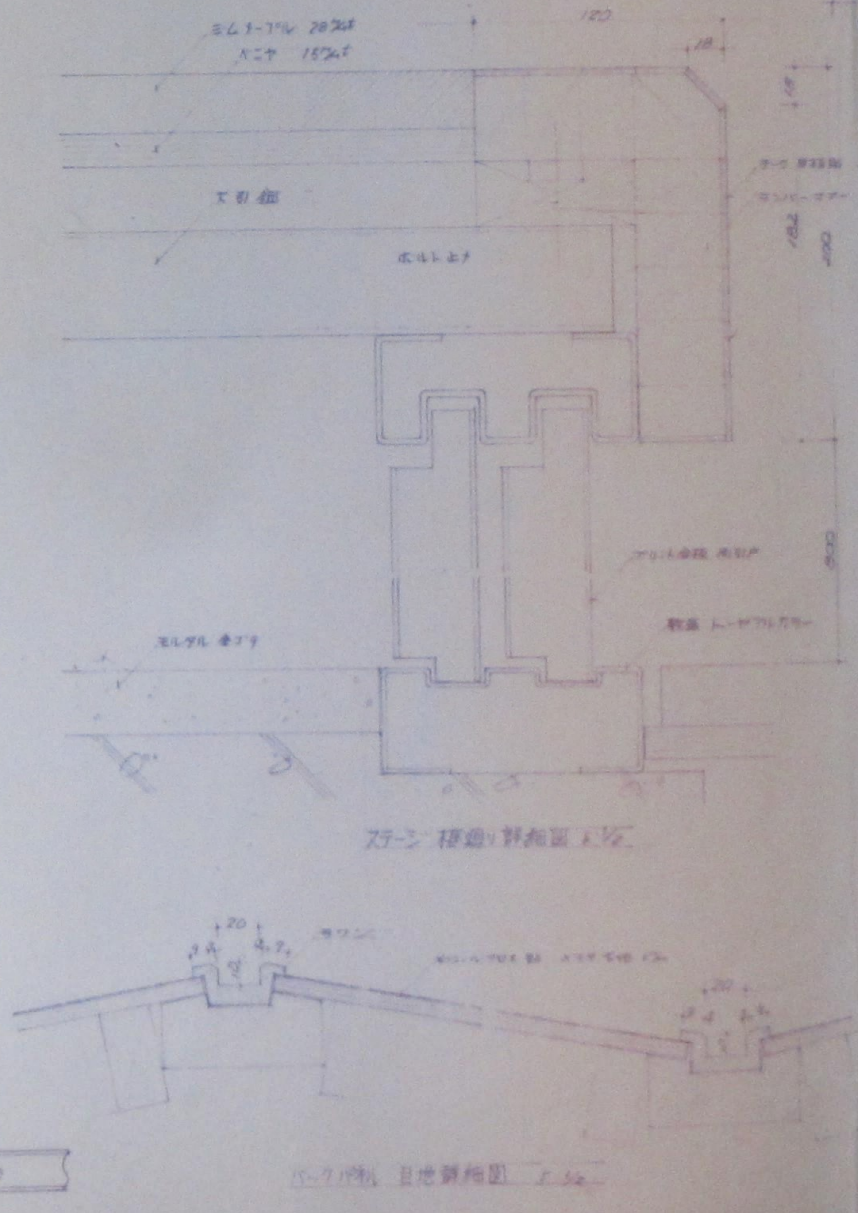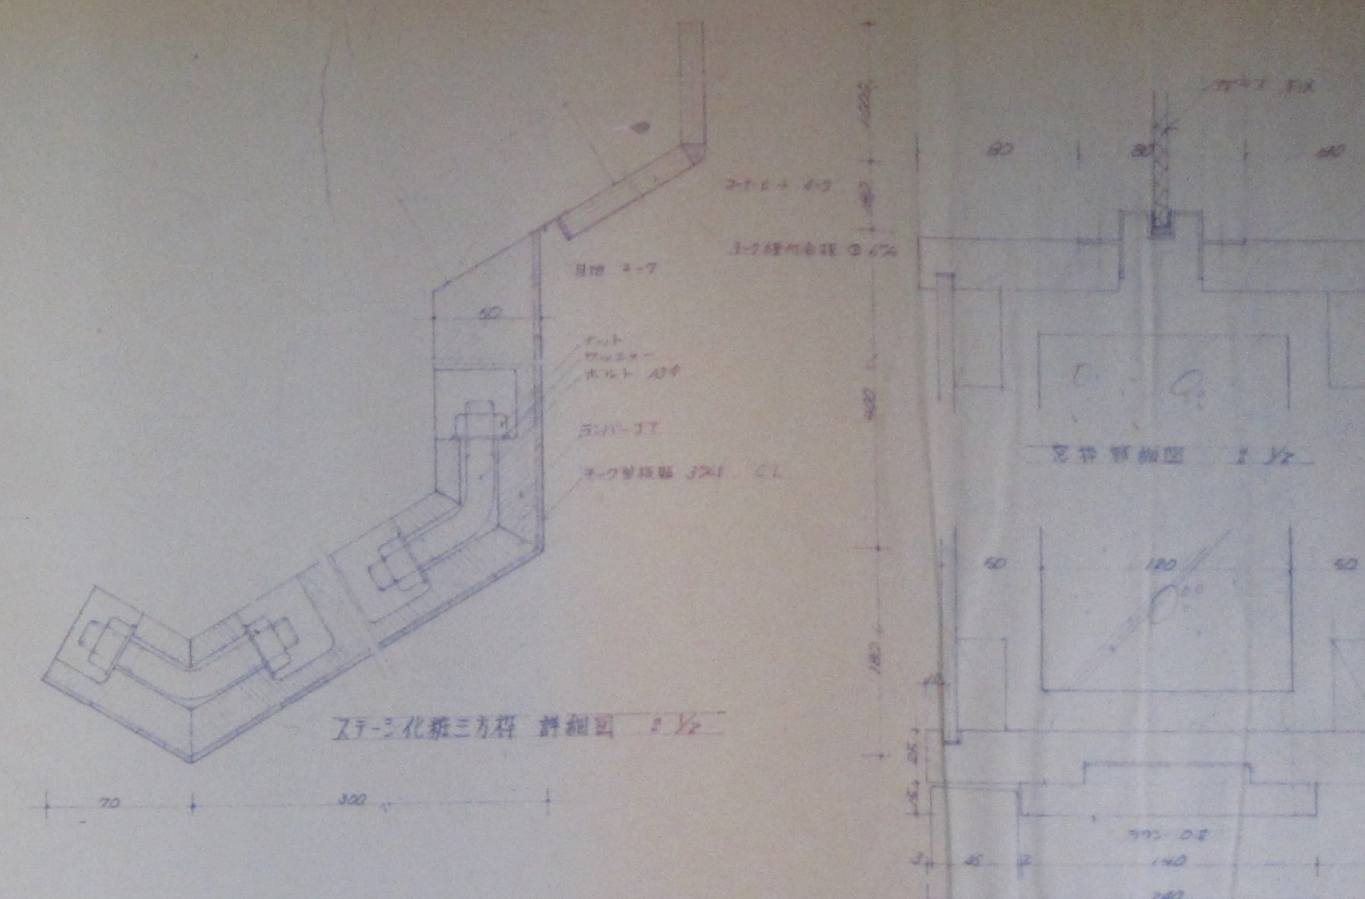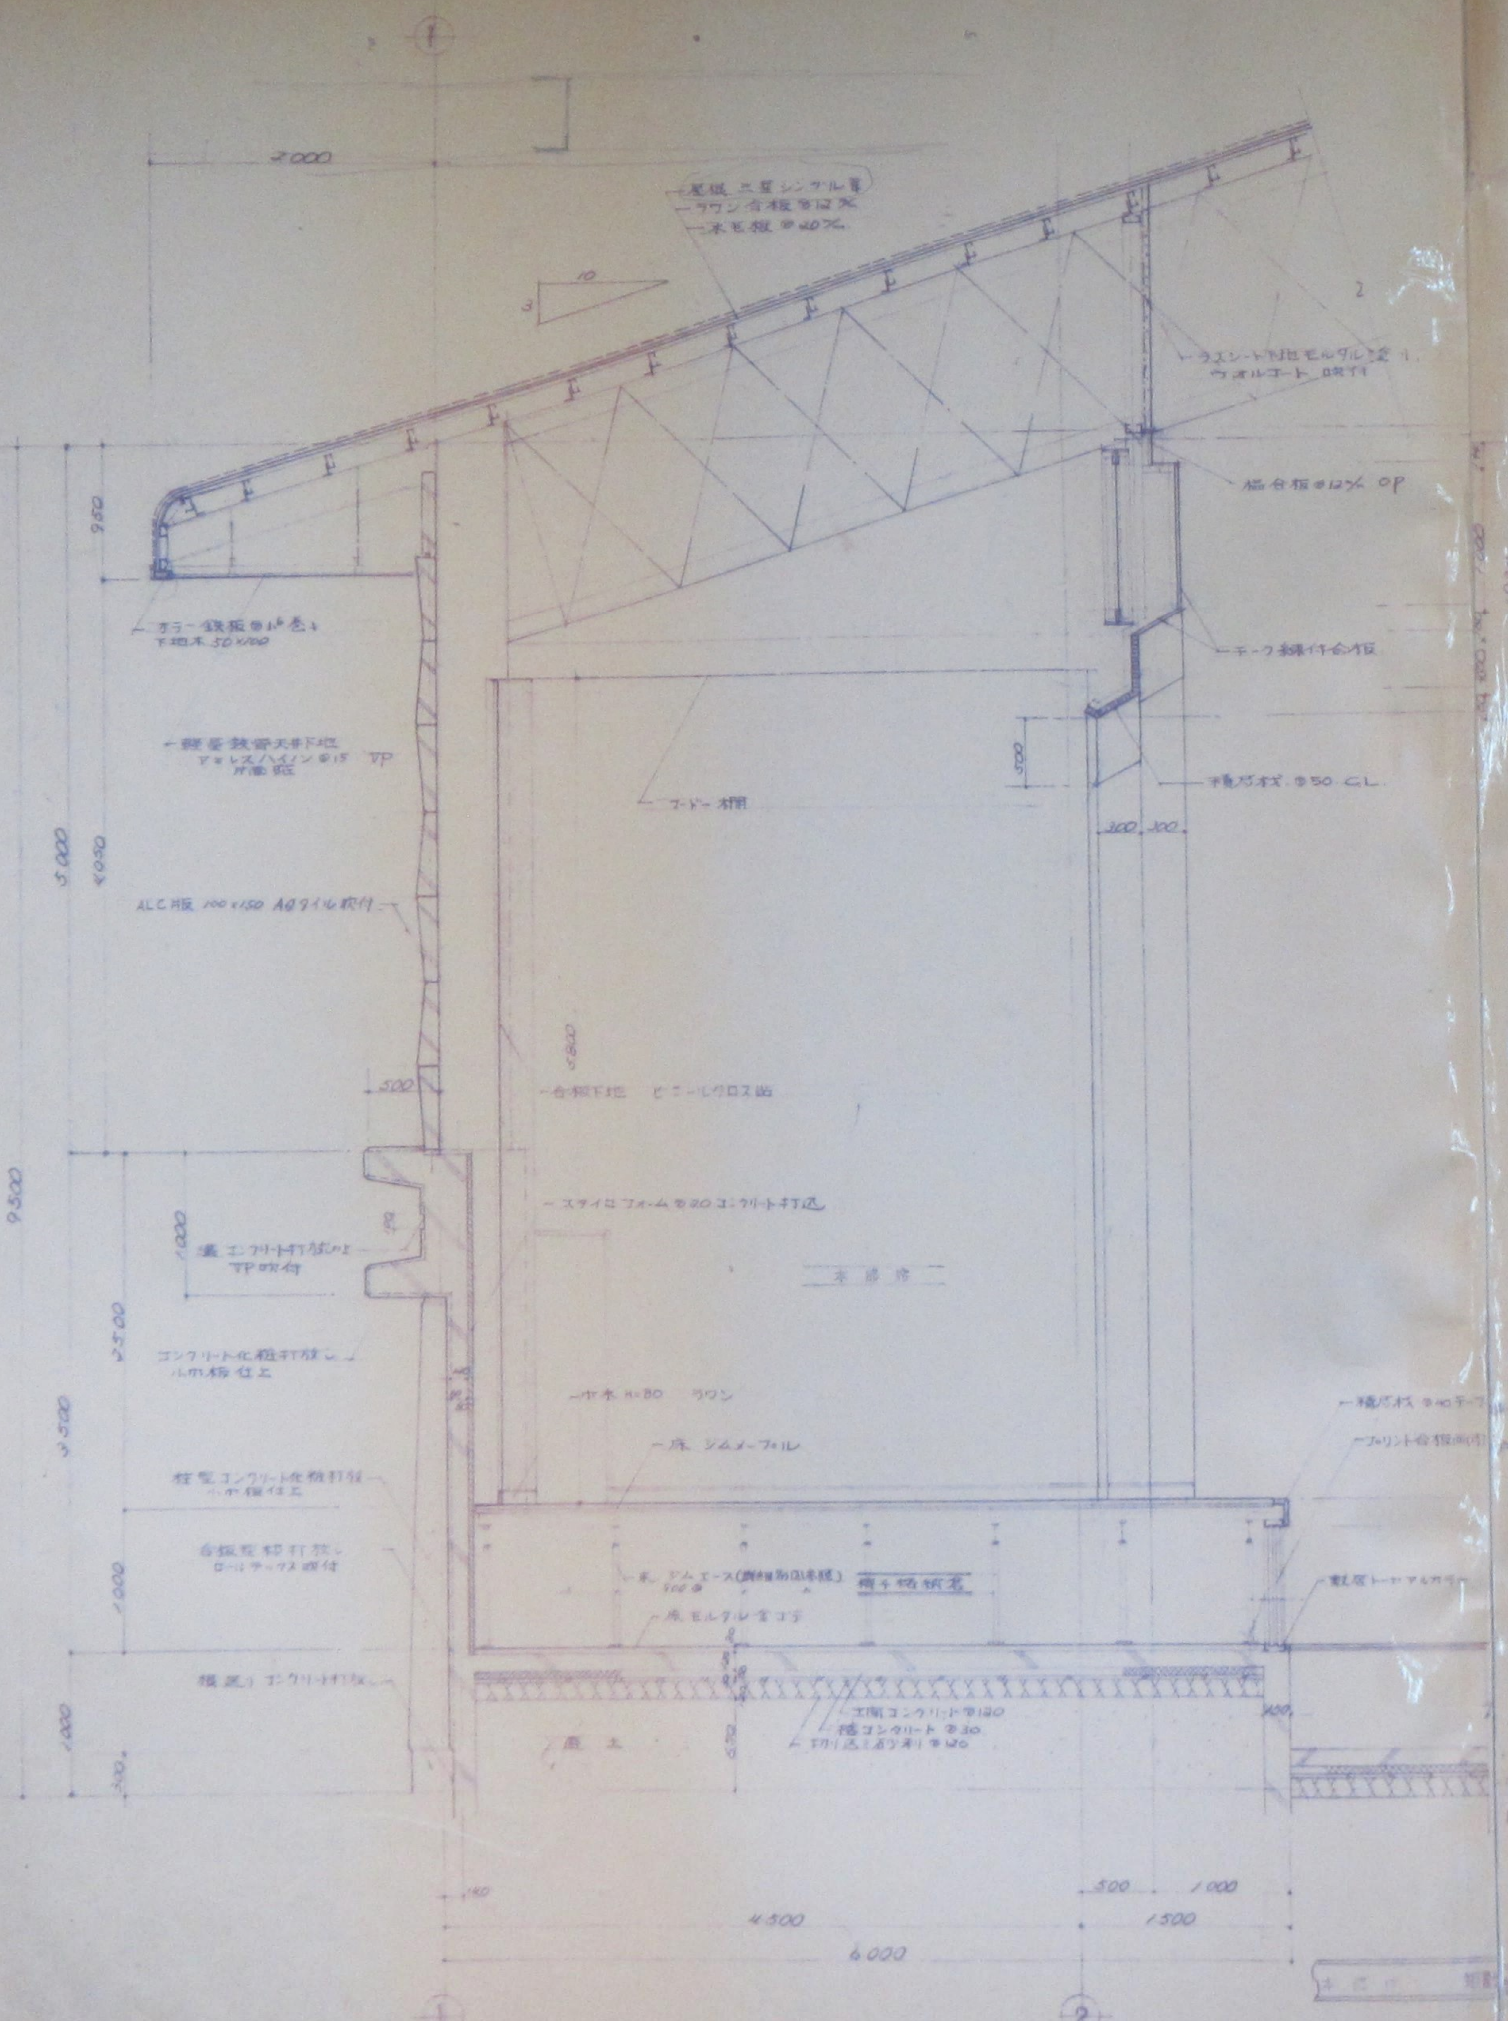

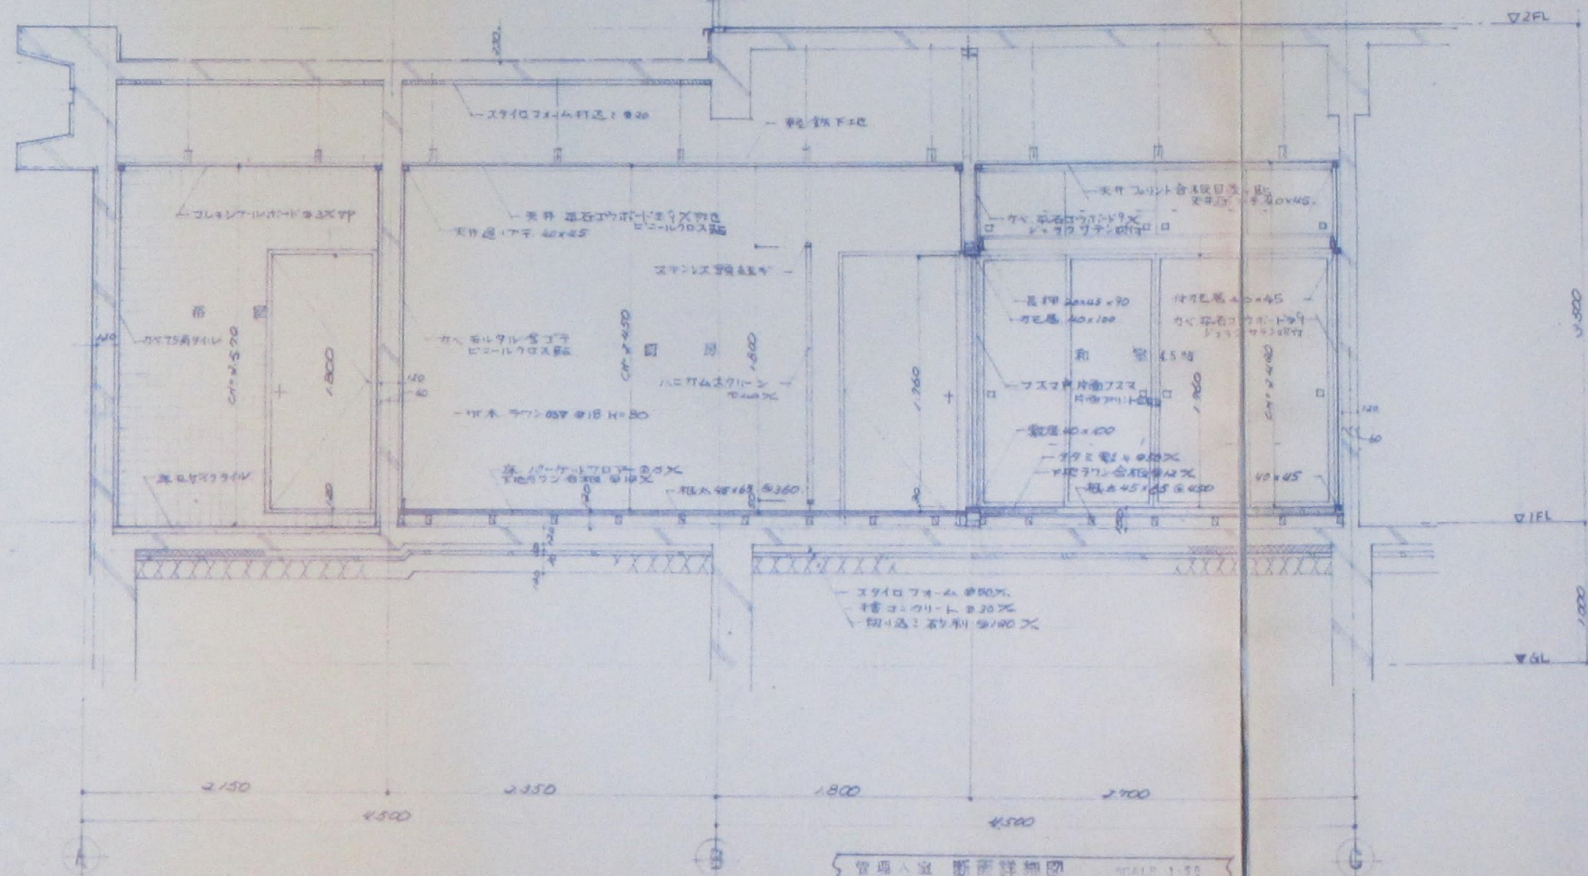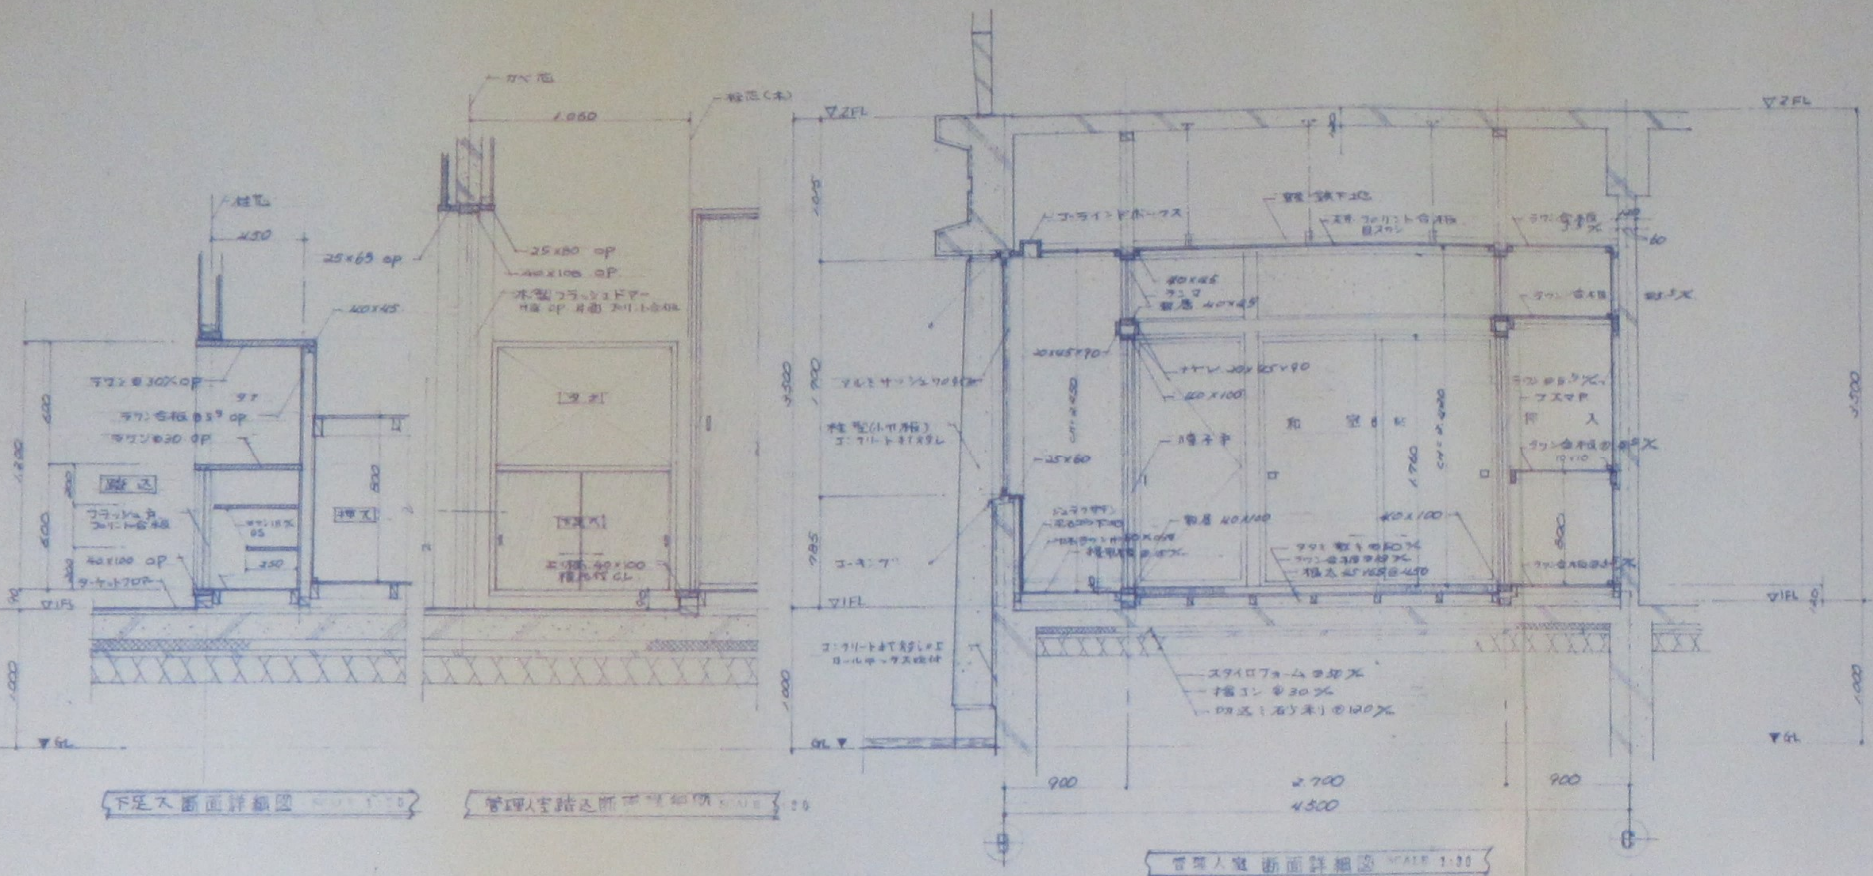


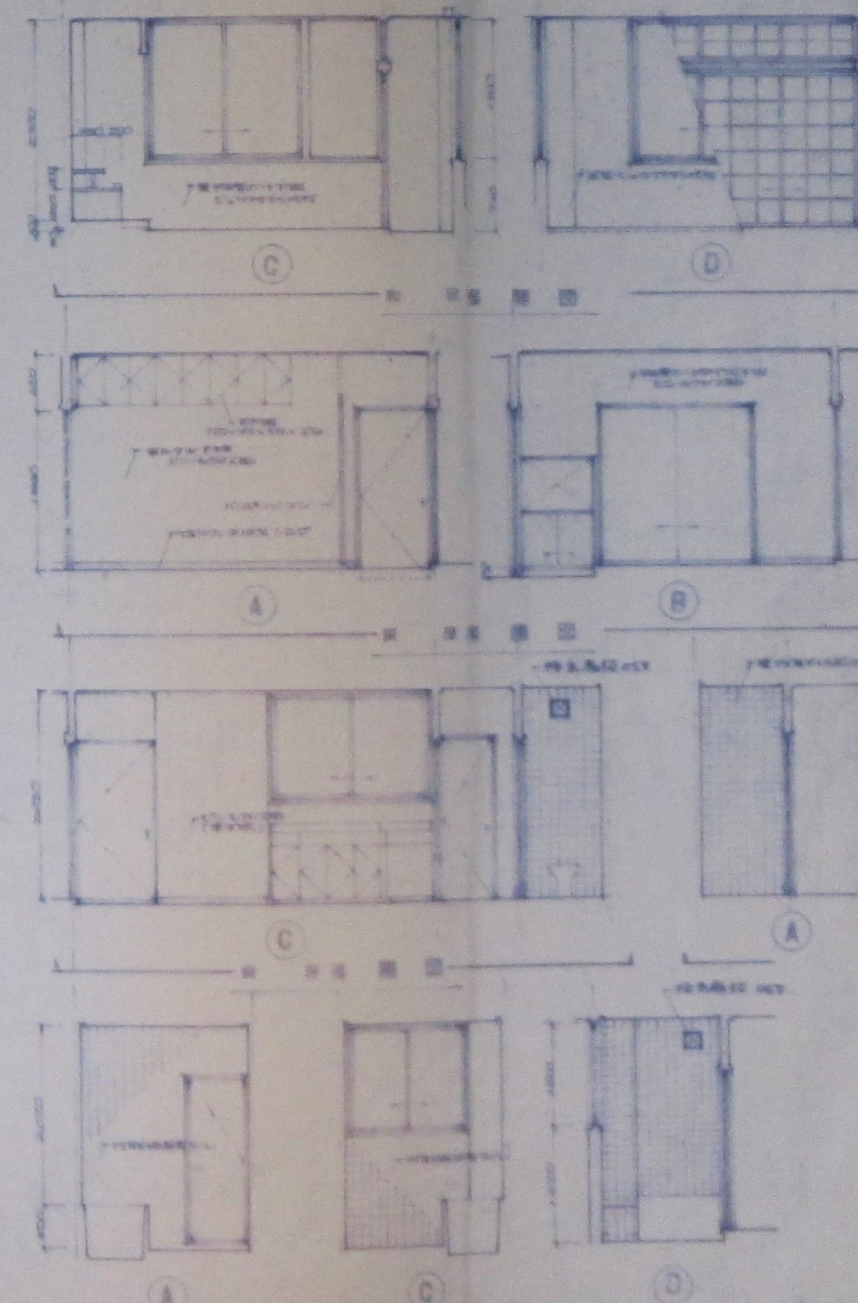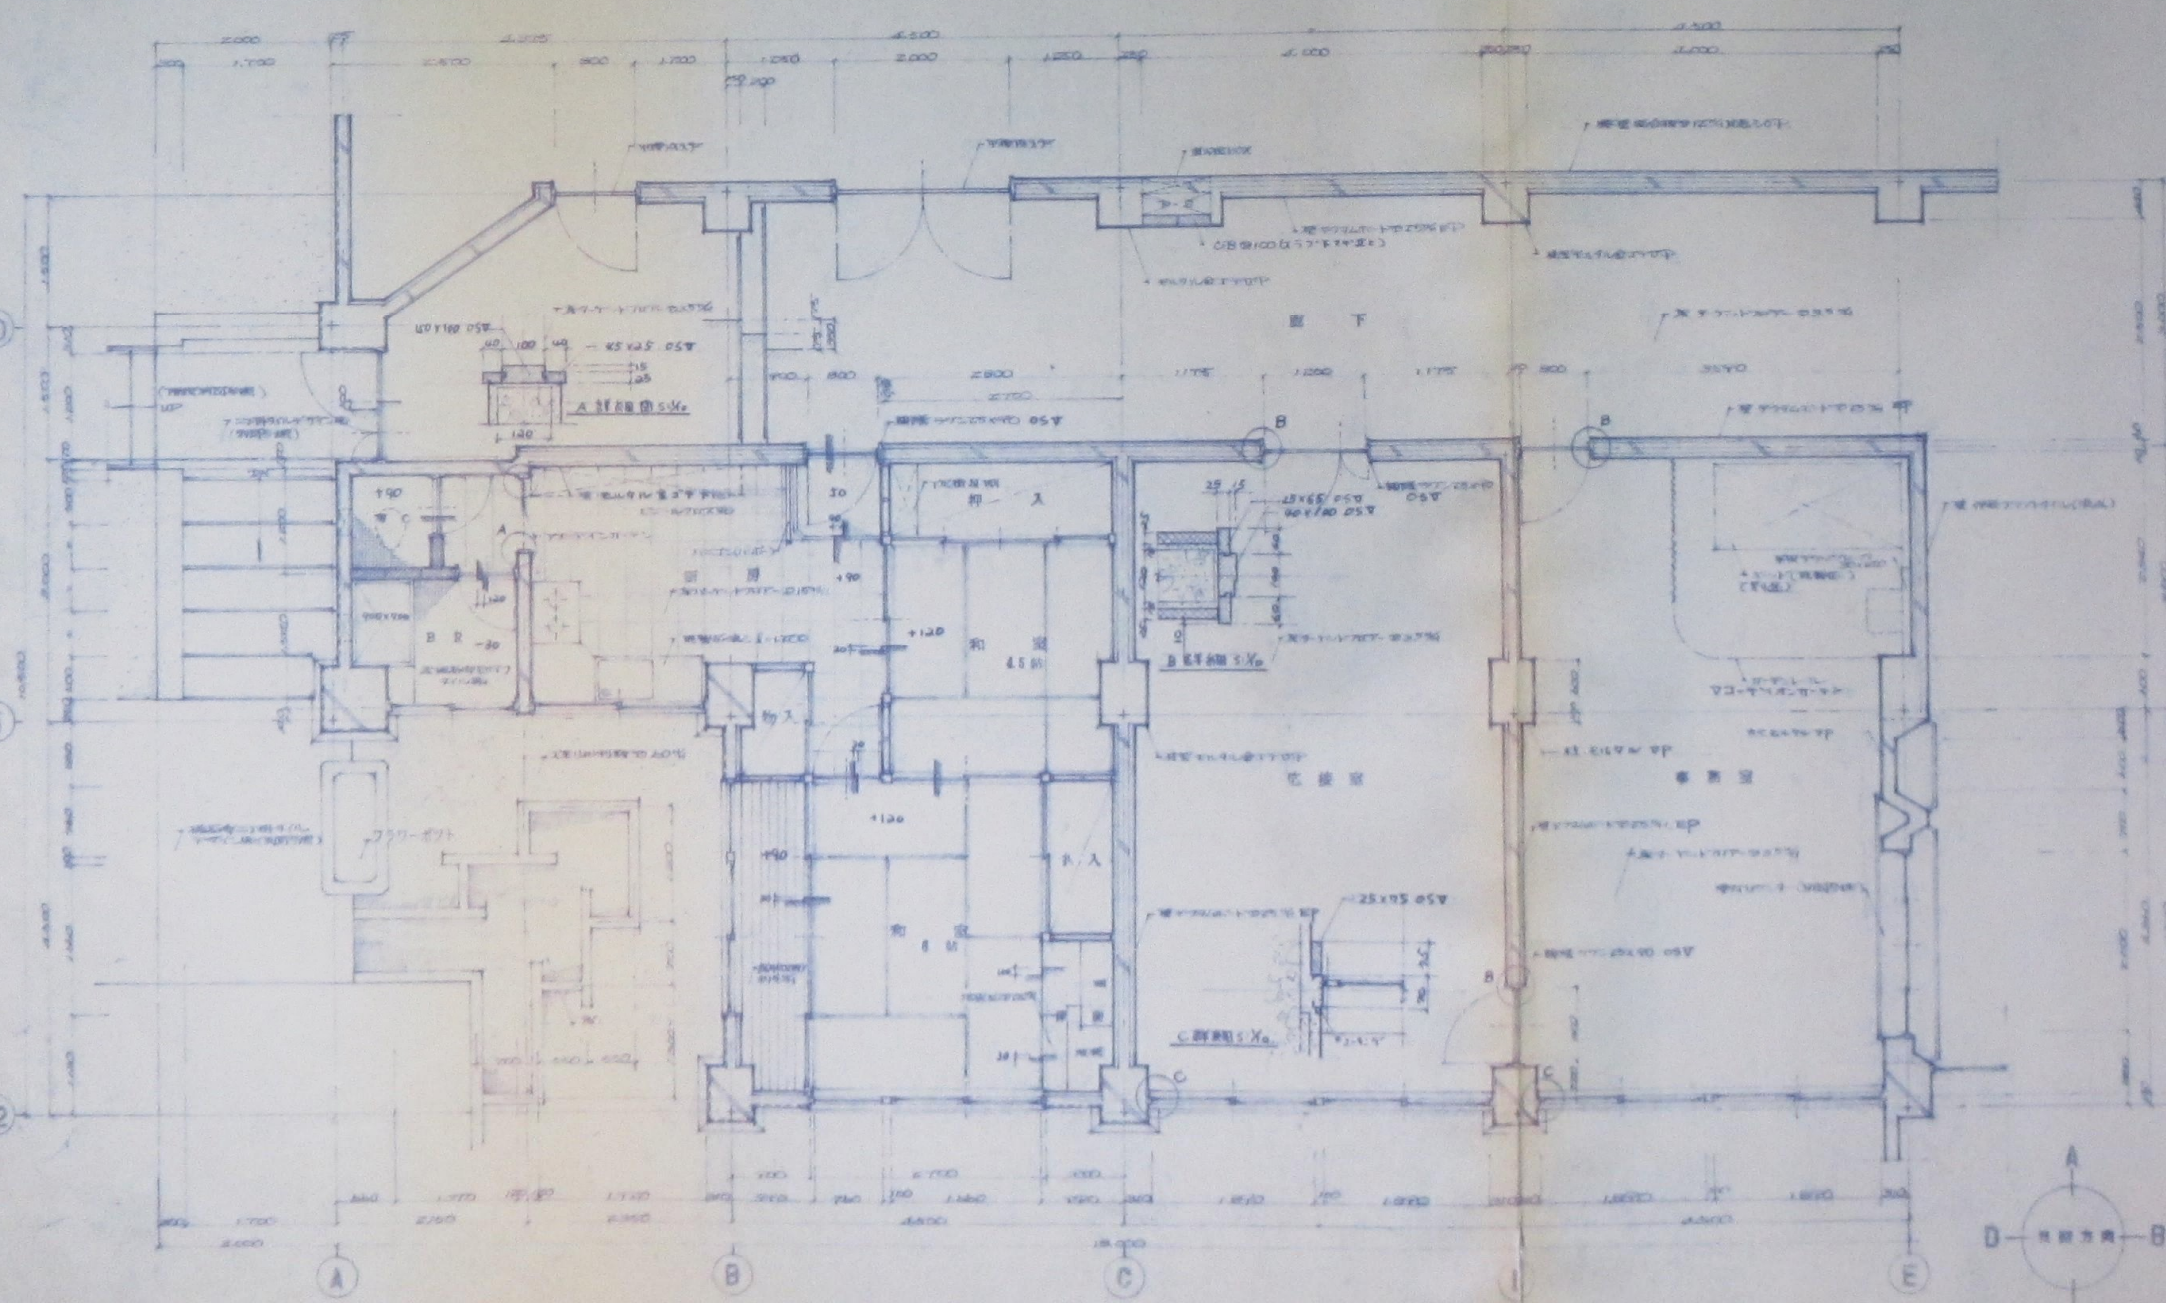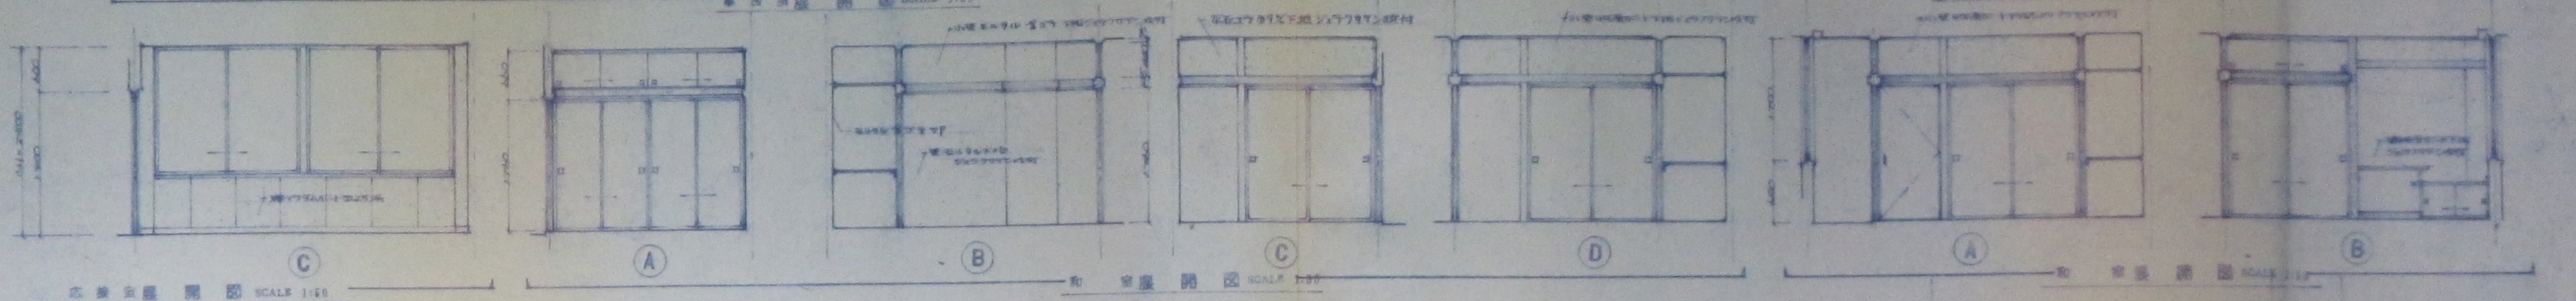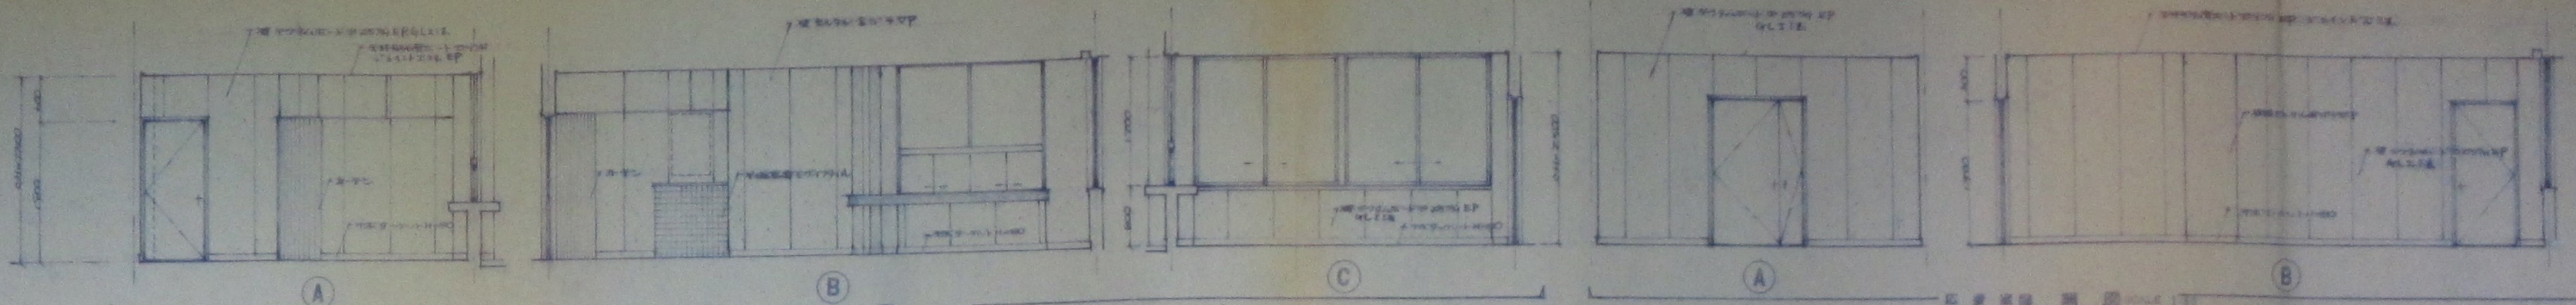

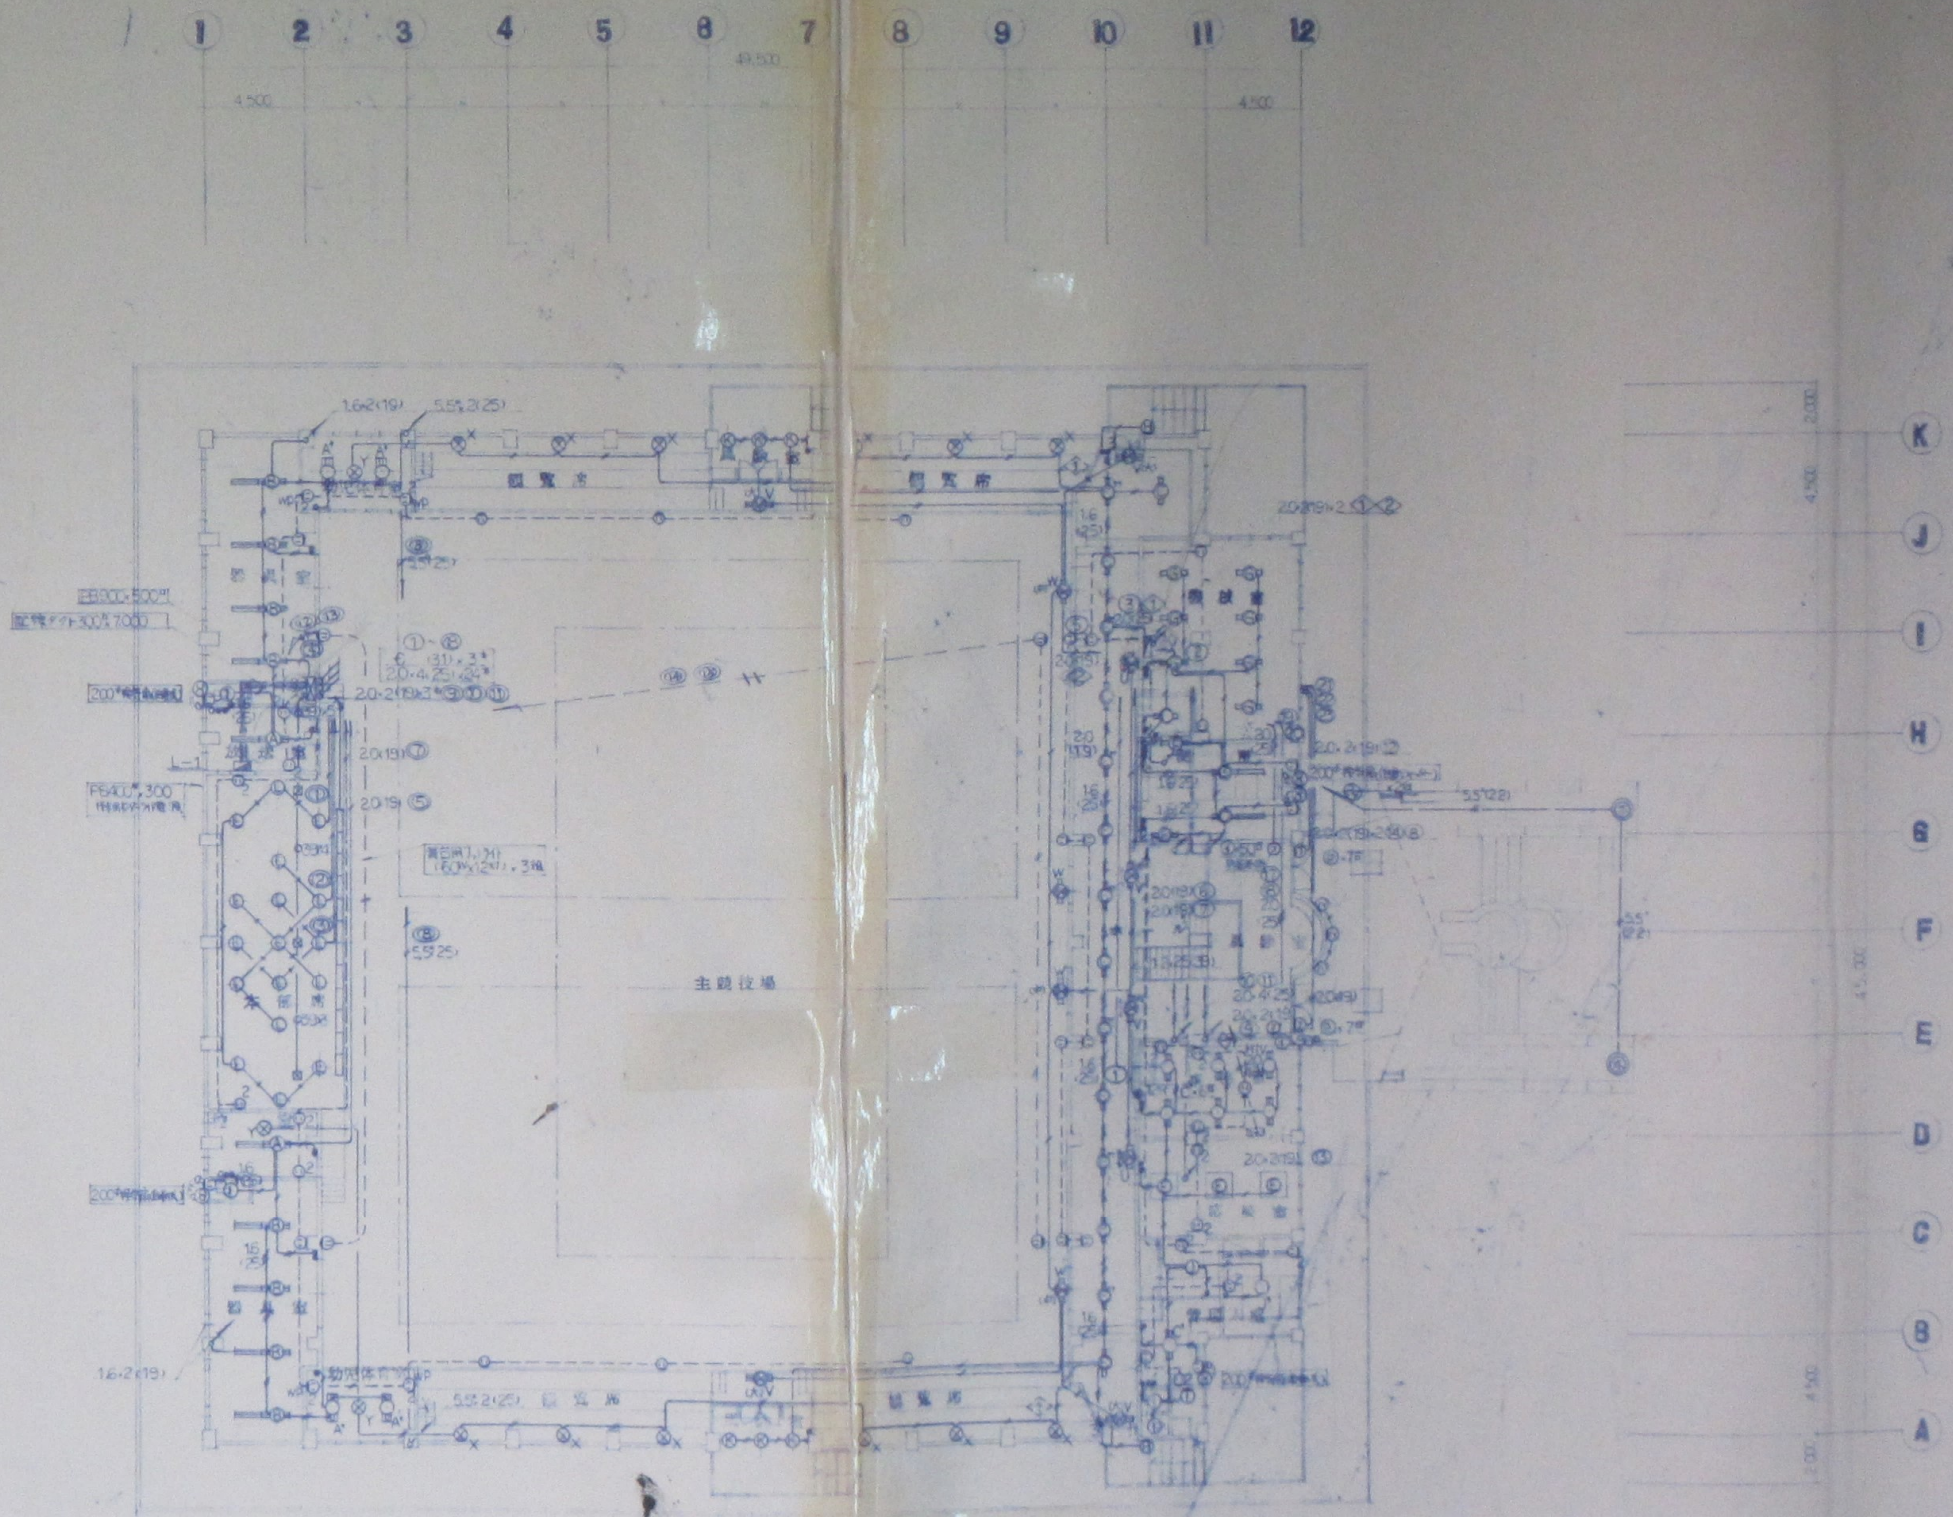


1階電灯コンセント配線図 SCALE 1/100


1 2 3 4 5 6 7 8 9 10 11 12

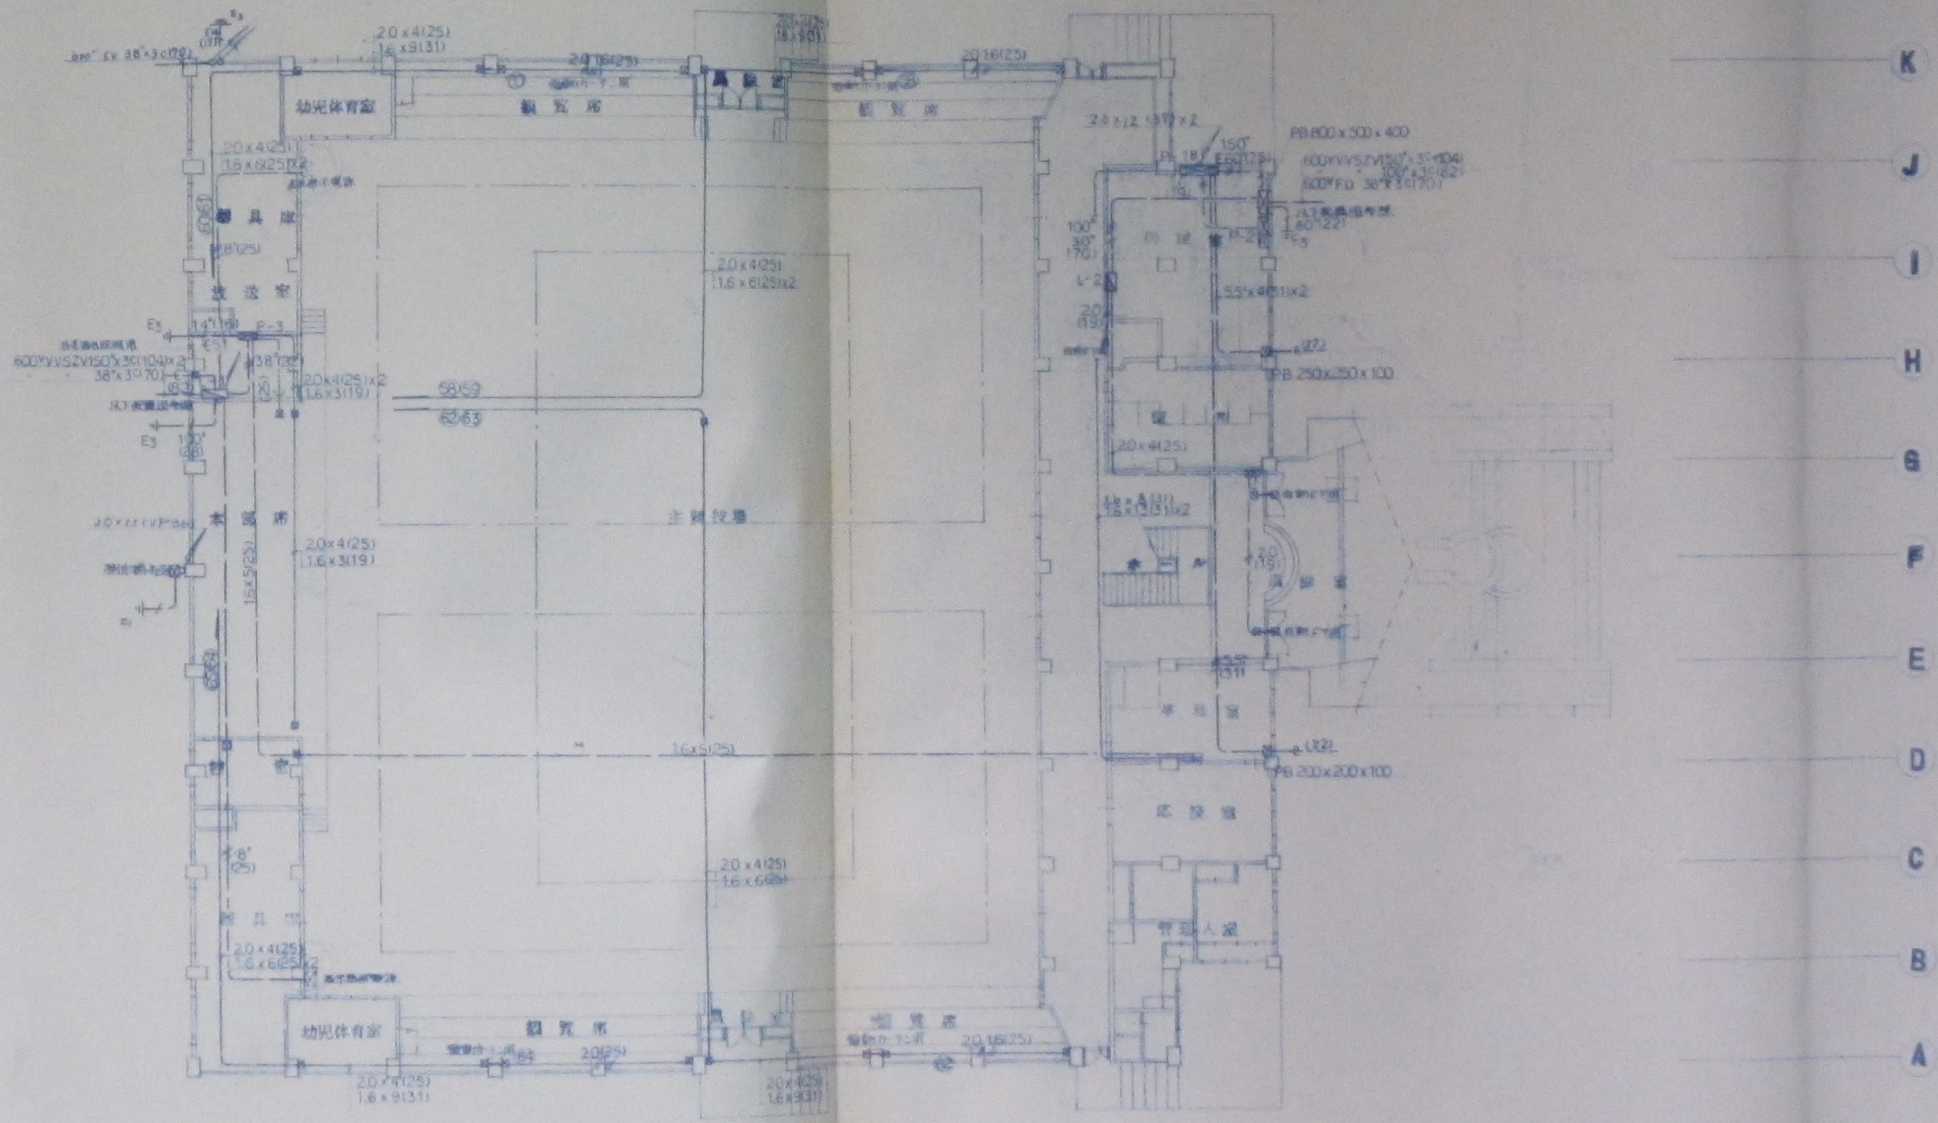

1 层管線圖(力學及電氣) (1/1)

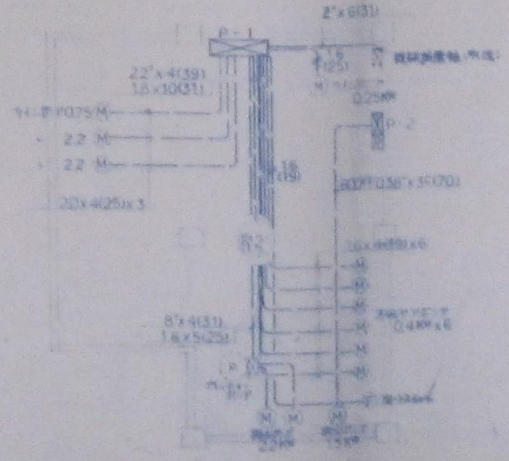


1 2 3 4 5 6 7 8 9 10 11 12

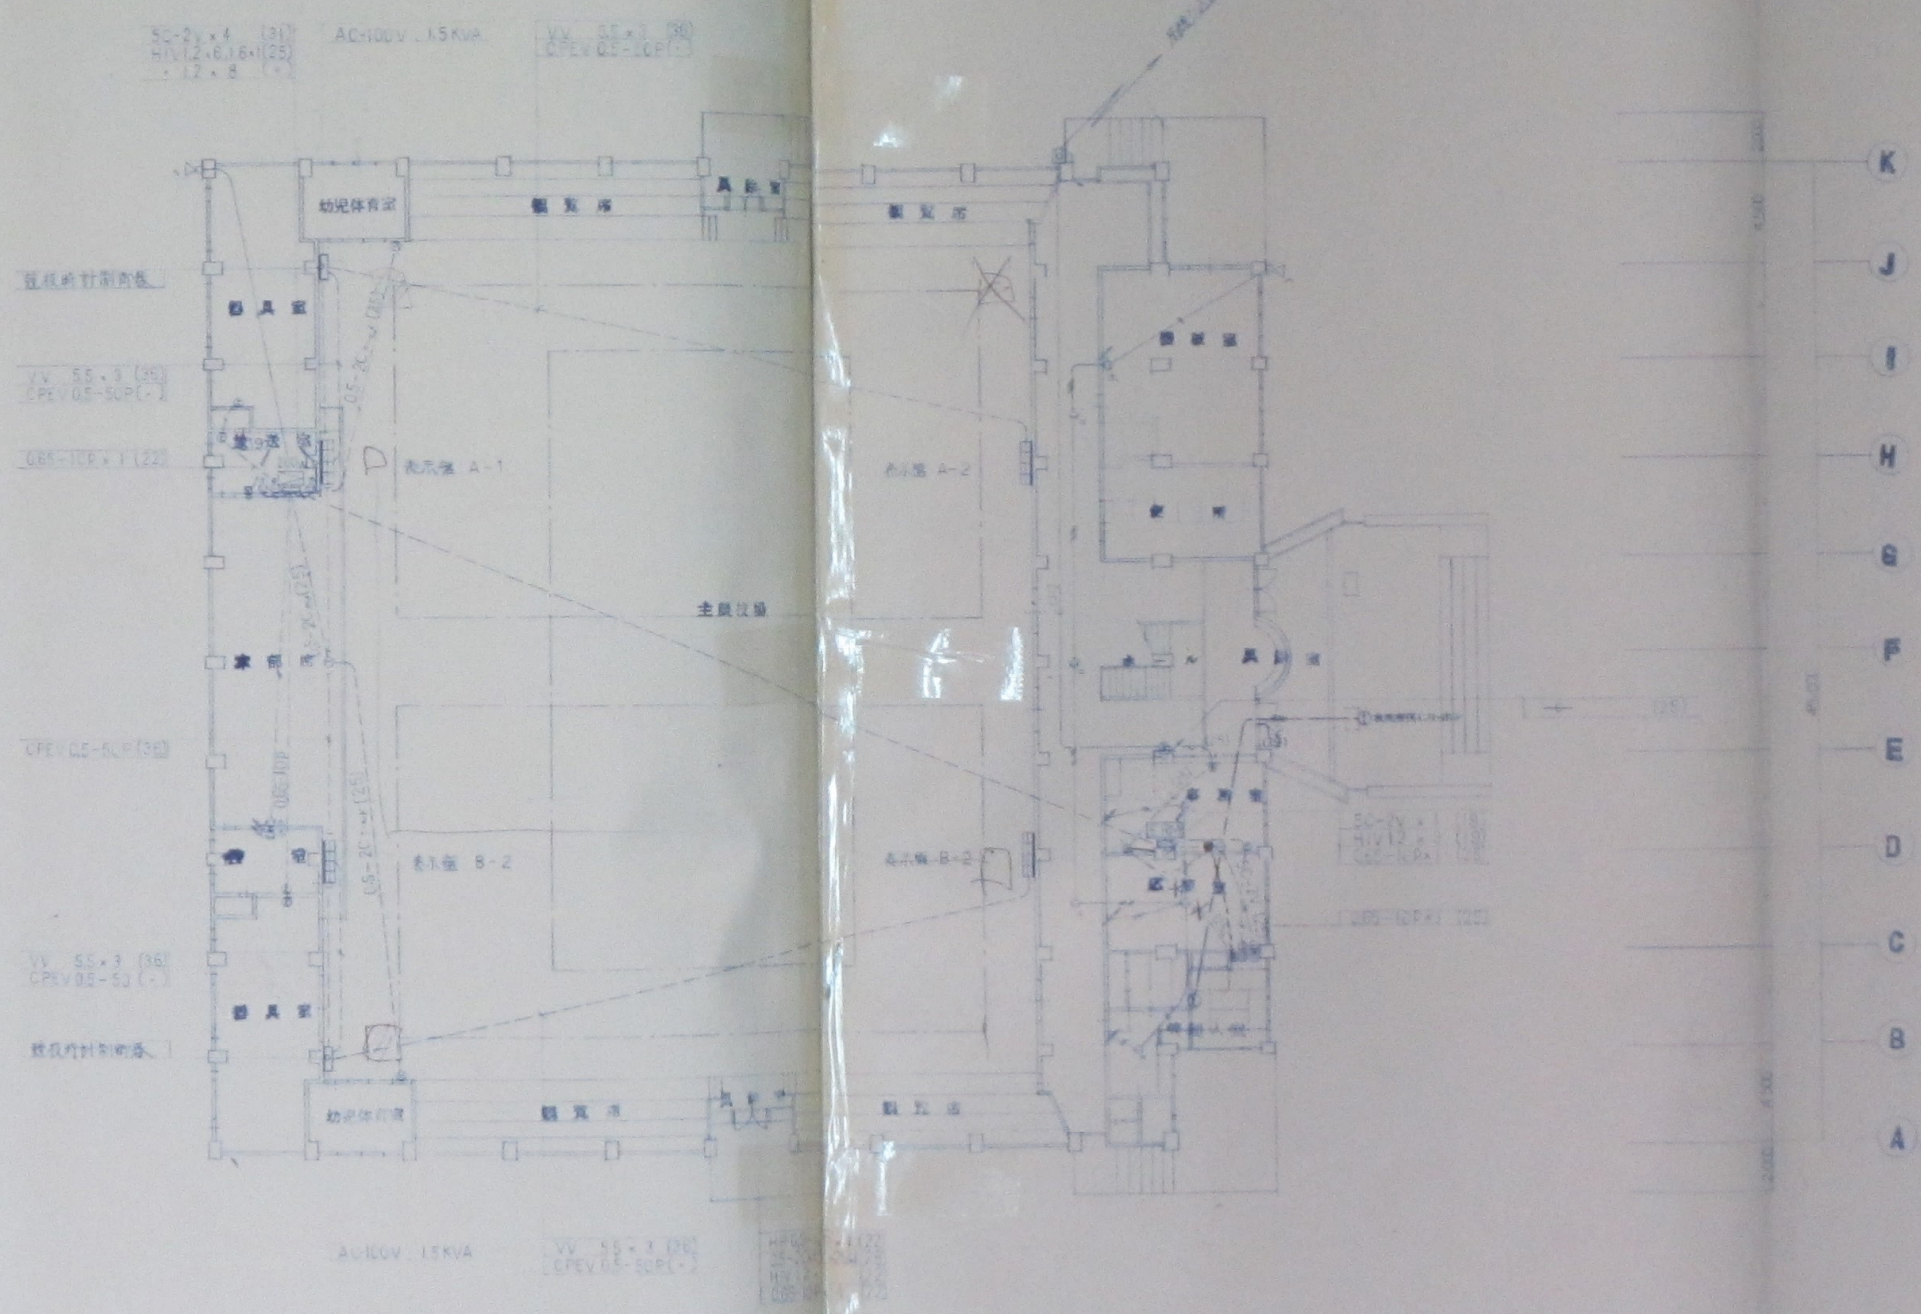

1:1 本圖之尺寸均按圖中尺寸為準(2019.12)

1 附圖之圖號與圖名

1 2 3 4 5 6 7 8 9 10 11 12

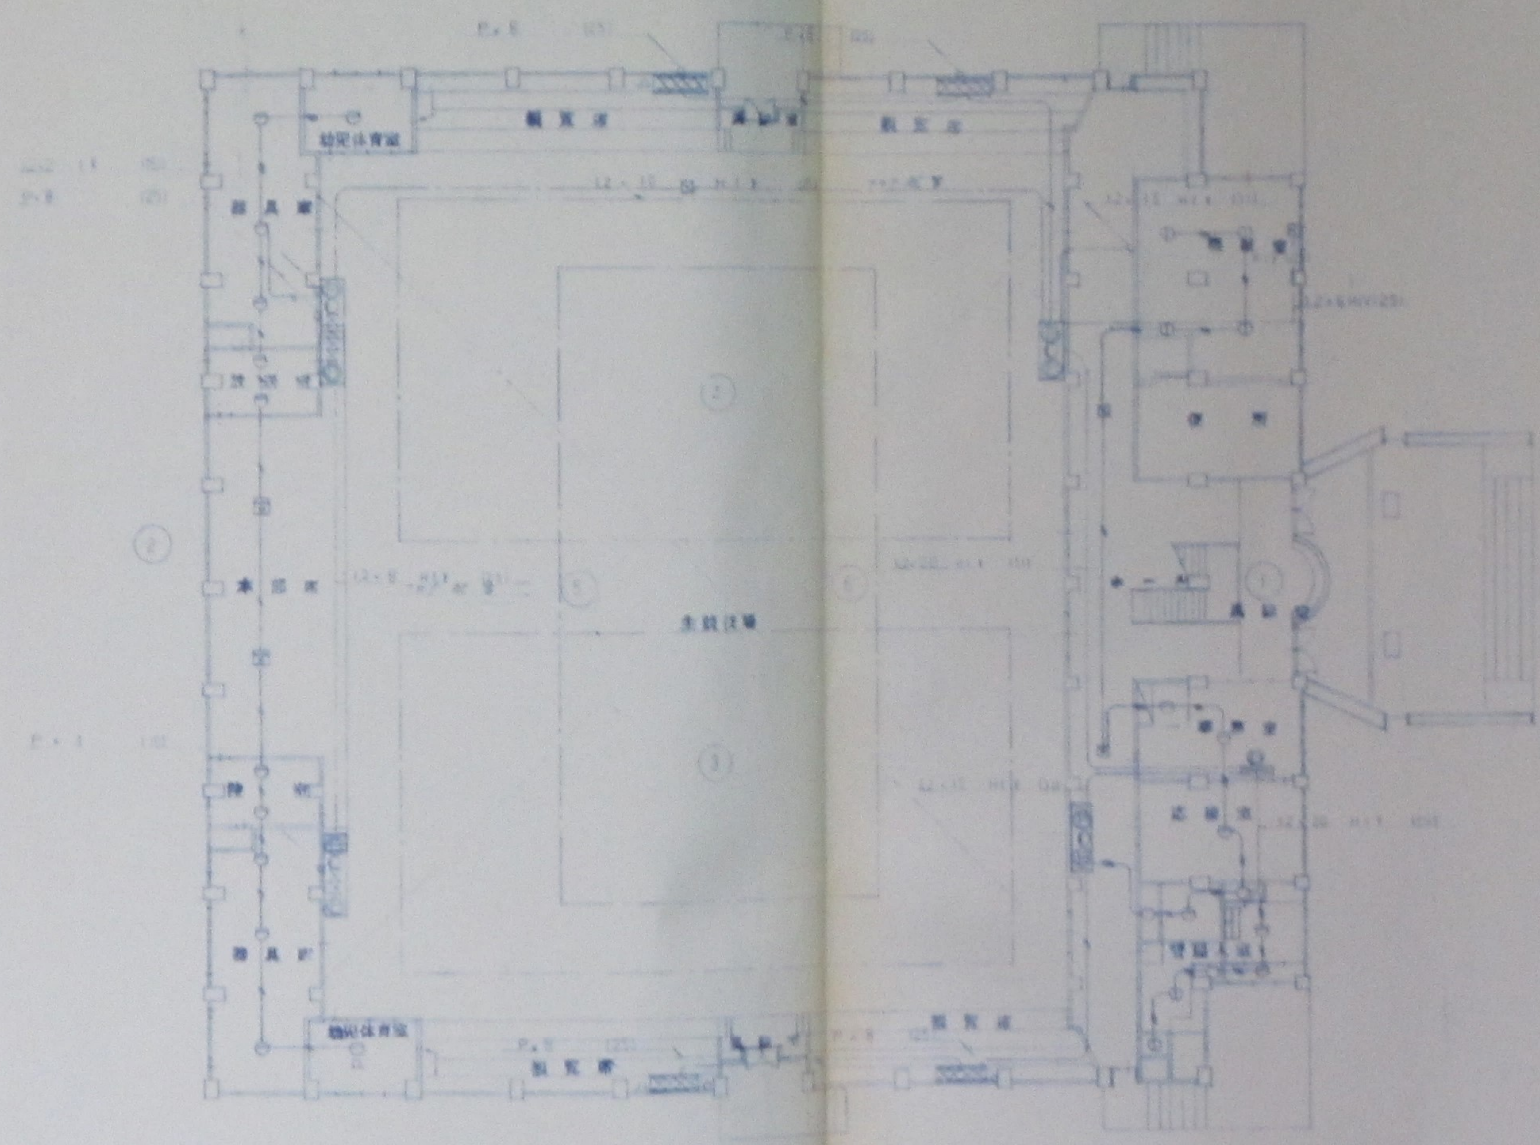

图一 大会堂平面布置图

图例

设计名称 黄石市人民体育馆新馆工程

设计单位

设计日期