

圖 1-1-1 電路圖

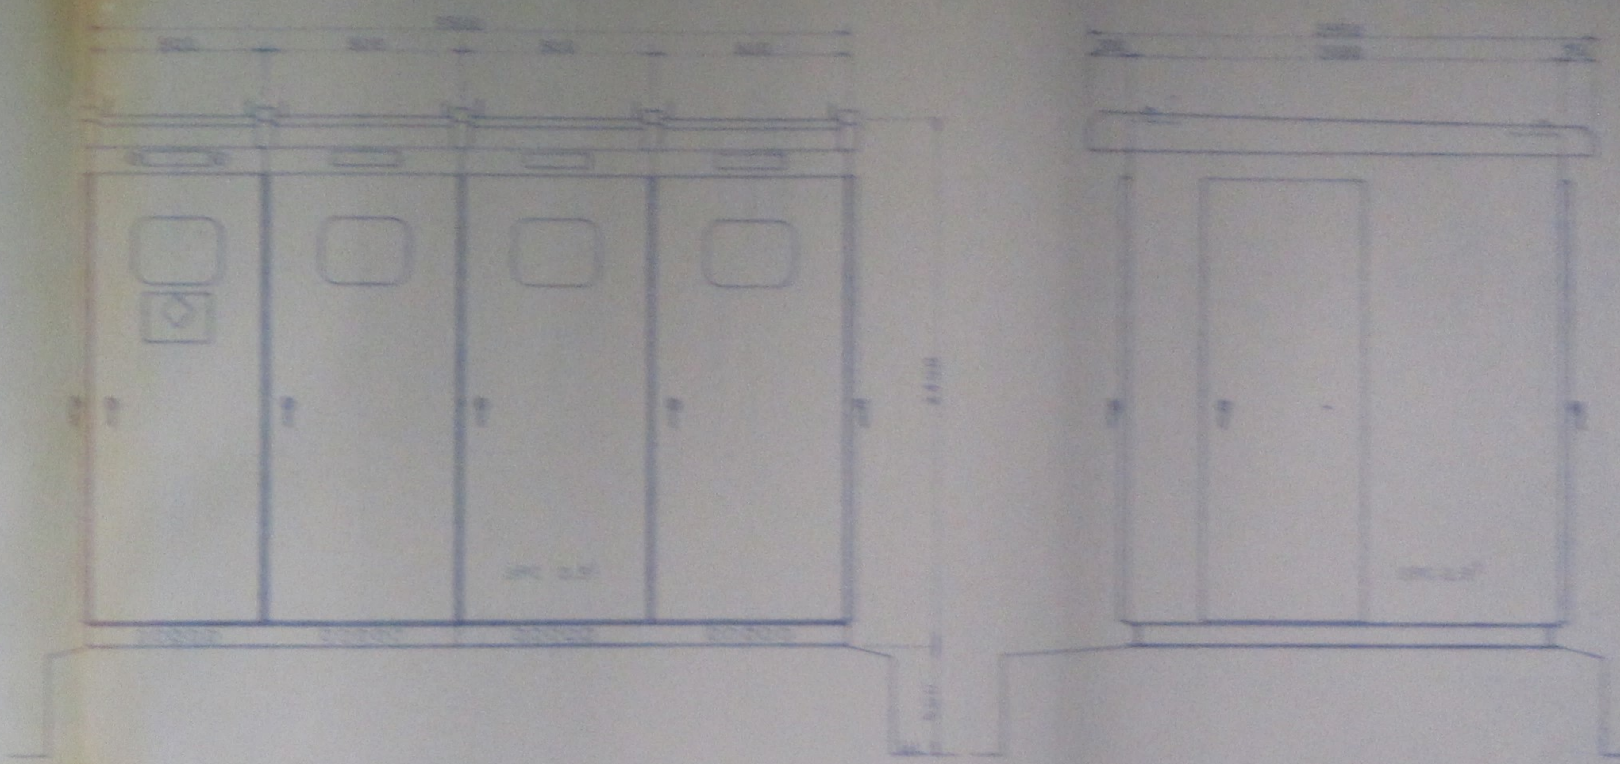


圖 1-1-2 櫃圖







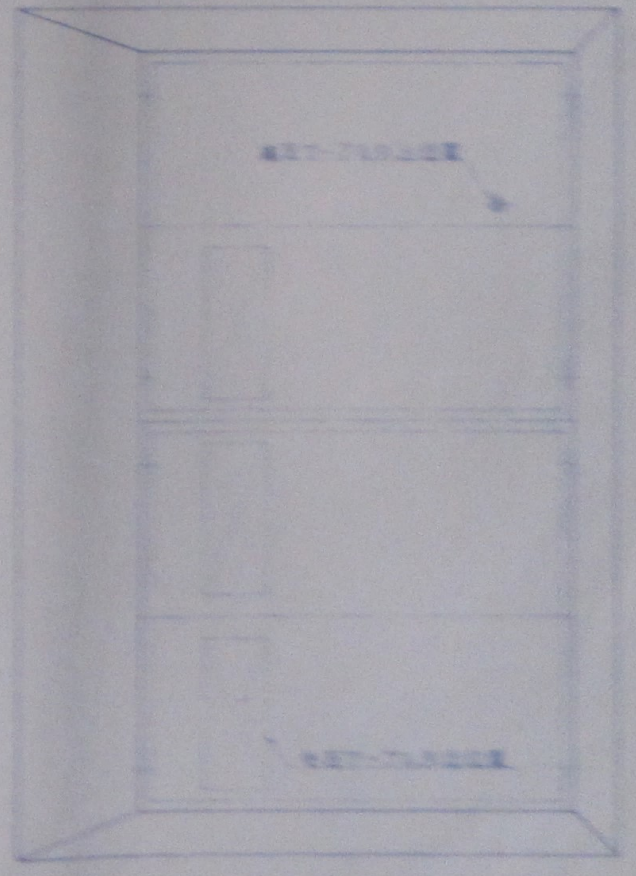


圖 1-1-3 櫃圖

 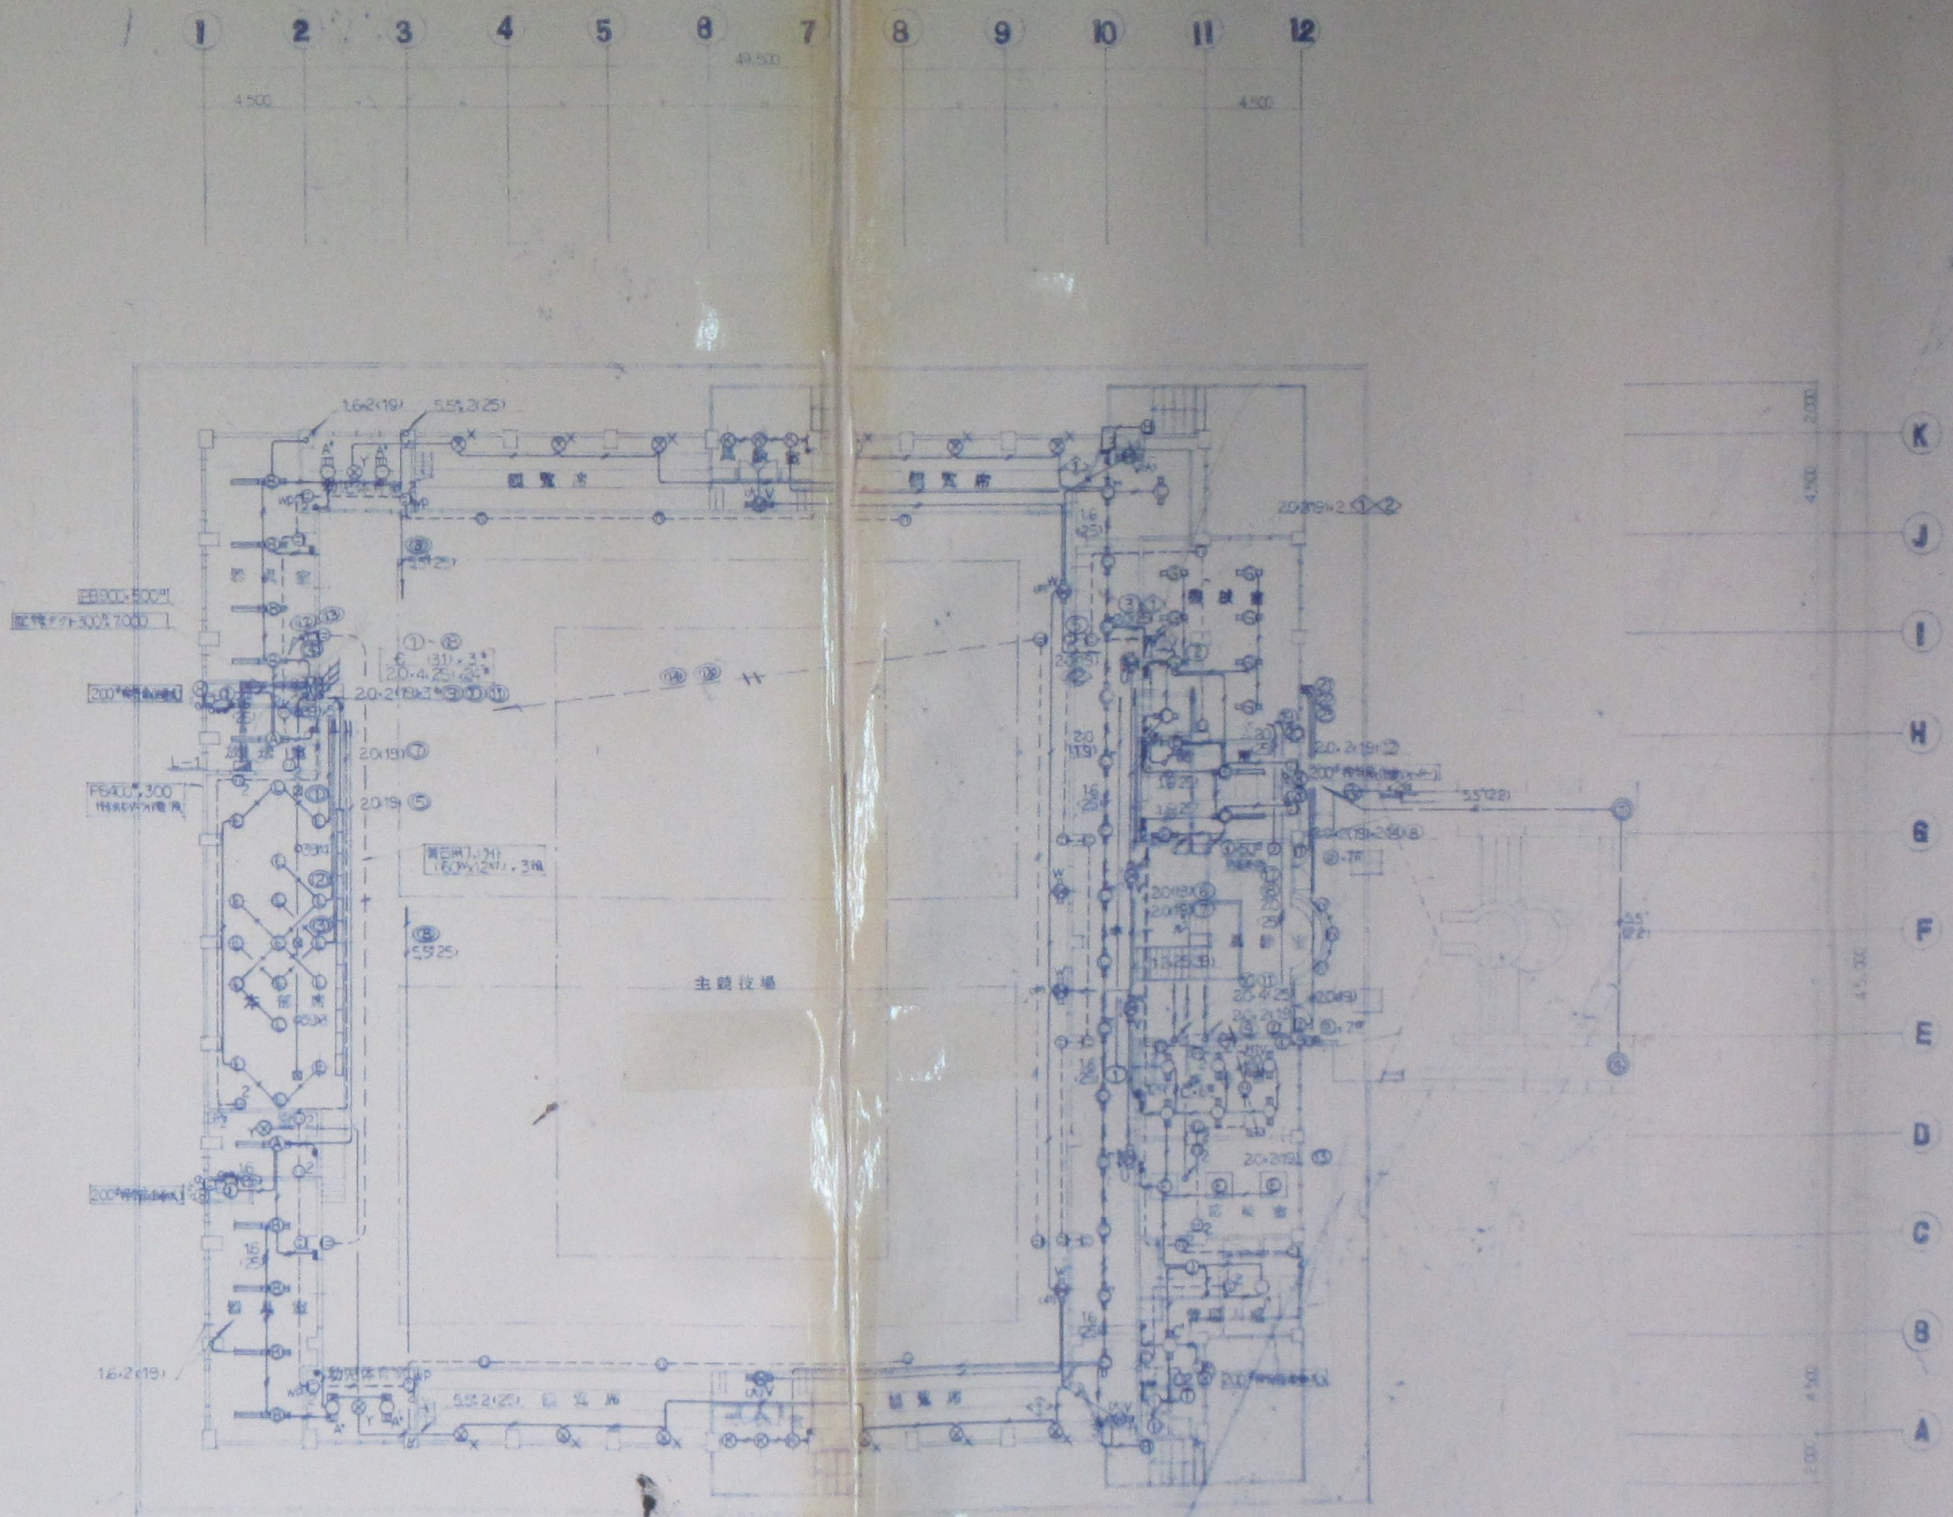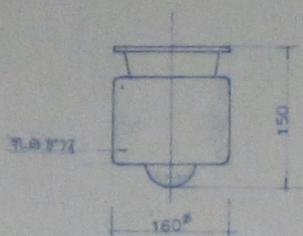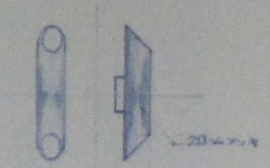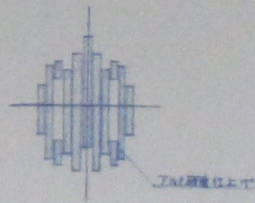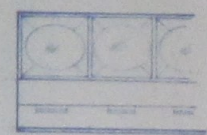


1階電灯コンセント配線図 SCALE 1/100


照明器具要図

<p>① IL 60"</p> 	<p>② IL 25"</p> 
<p>③ IL 100"</p> 	<p>④ 60" x 12" x 7.1 x 4"</p> 
<p>⑤ HT 200"</p> <p>吊钩式器具 設置用吊钩</p> 	


1 2 3 4 5 6 7 8 9 10 11 12

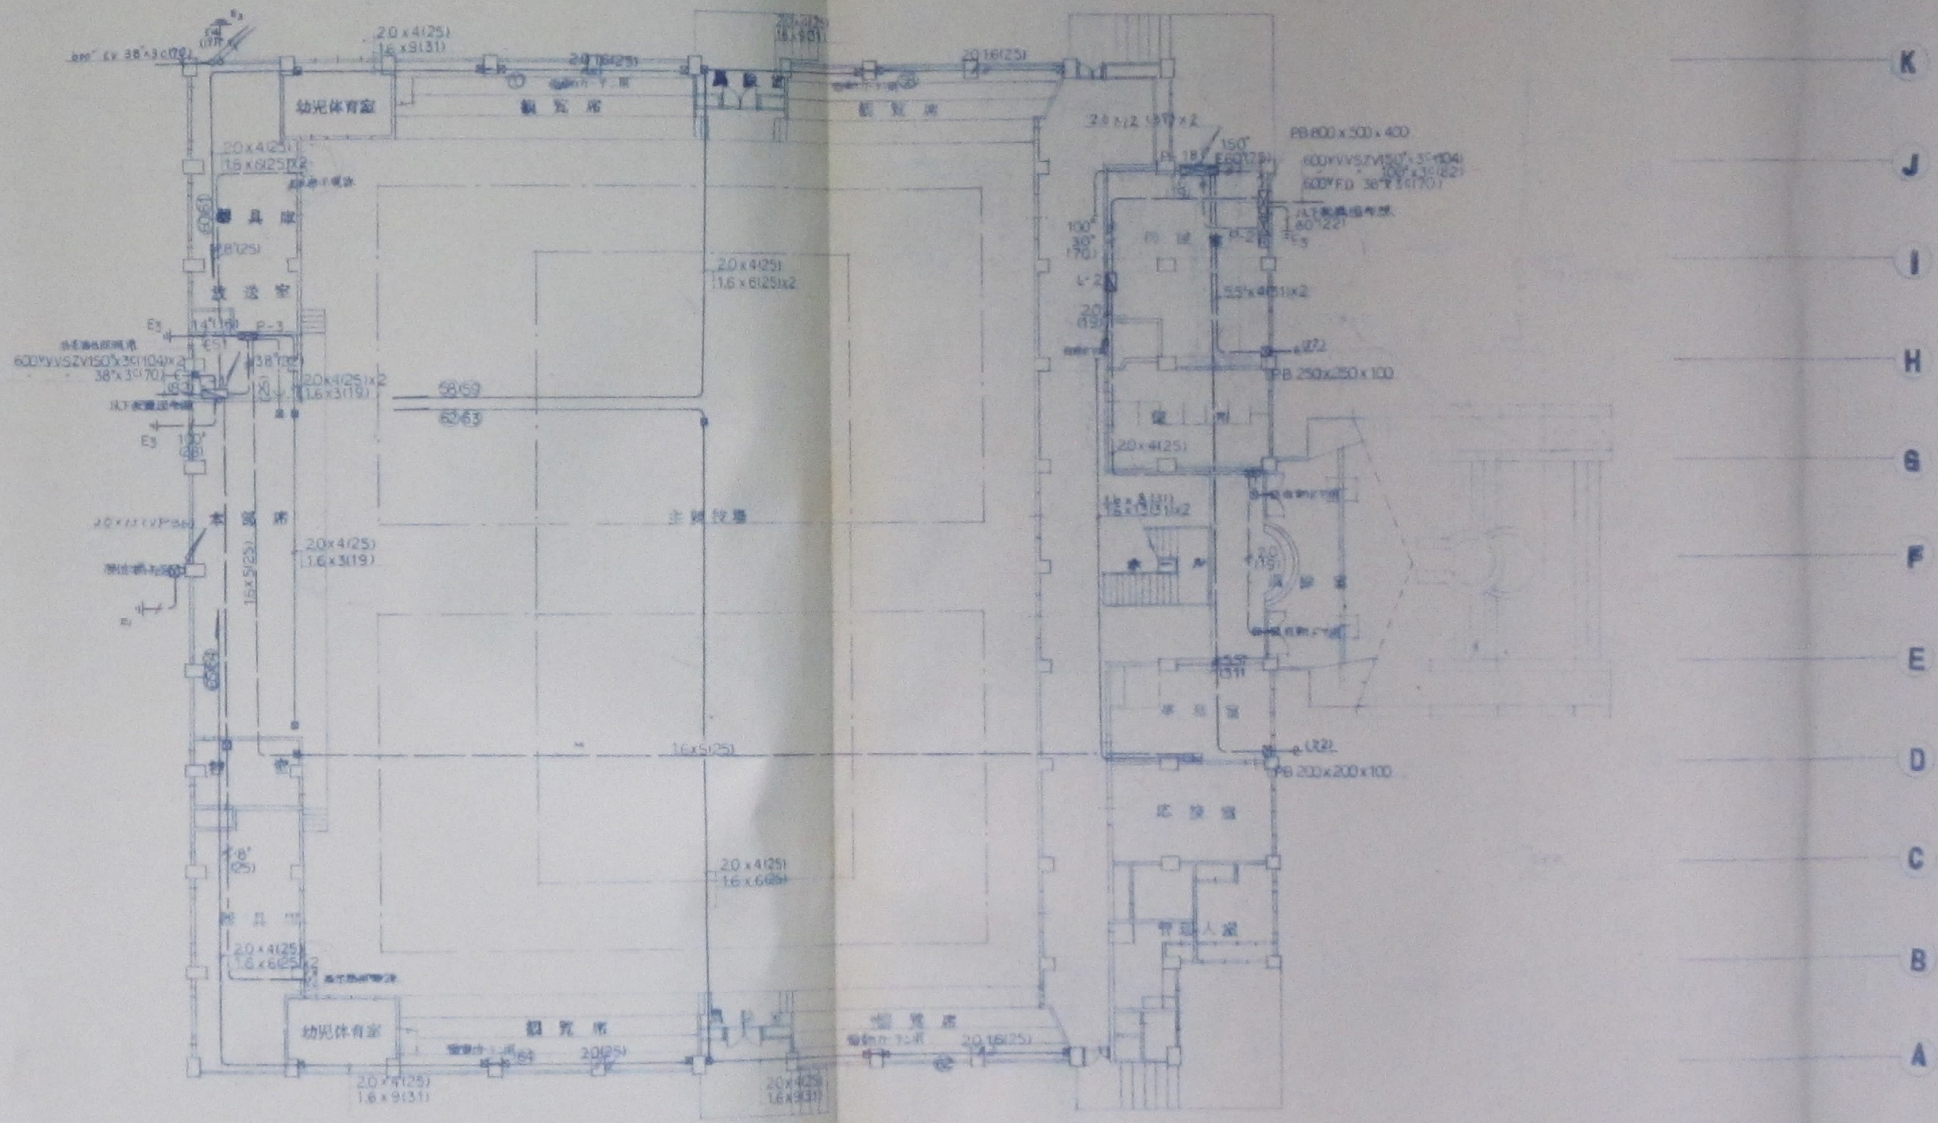

1 附楼一层剪力墙及梁板图

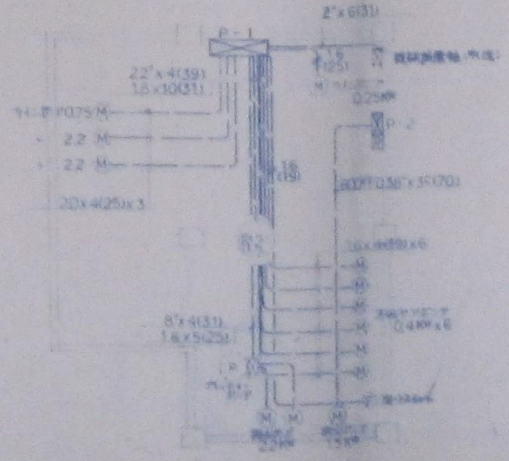

1 2 3 4 5 6 7 8 9 10 11 12

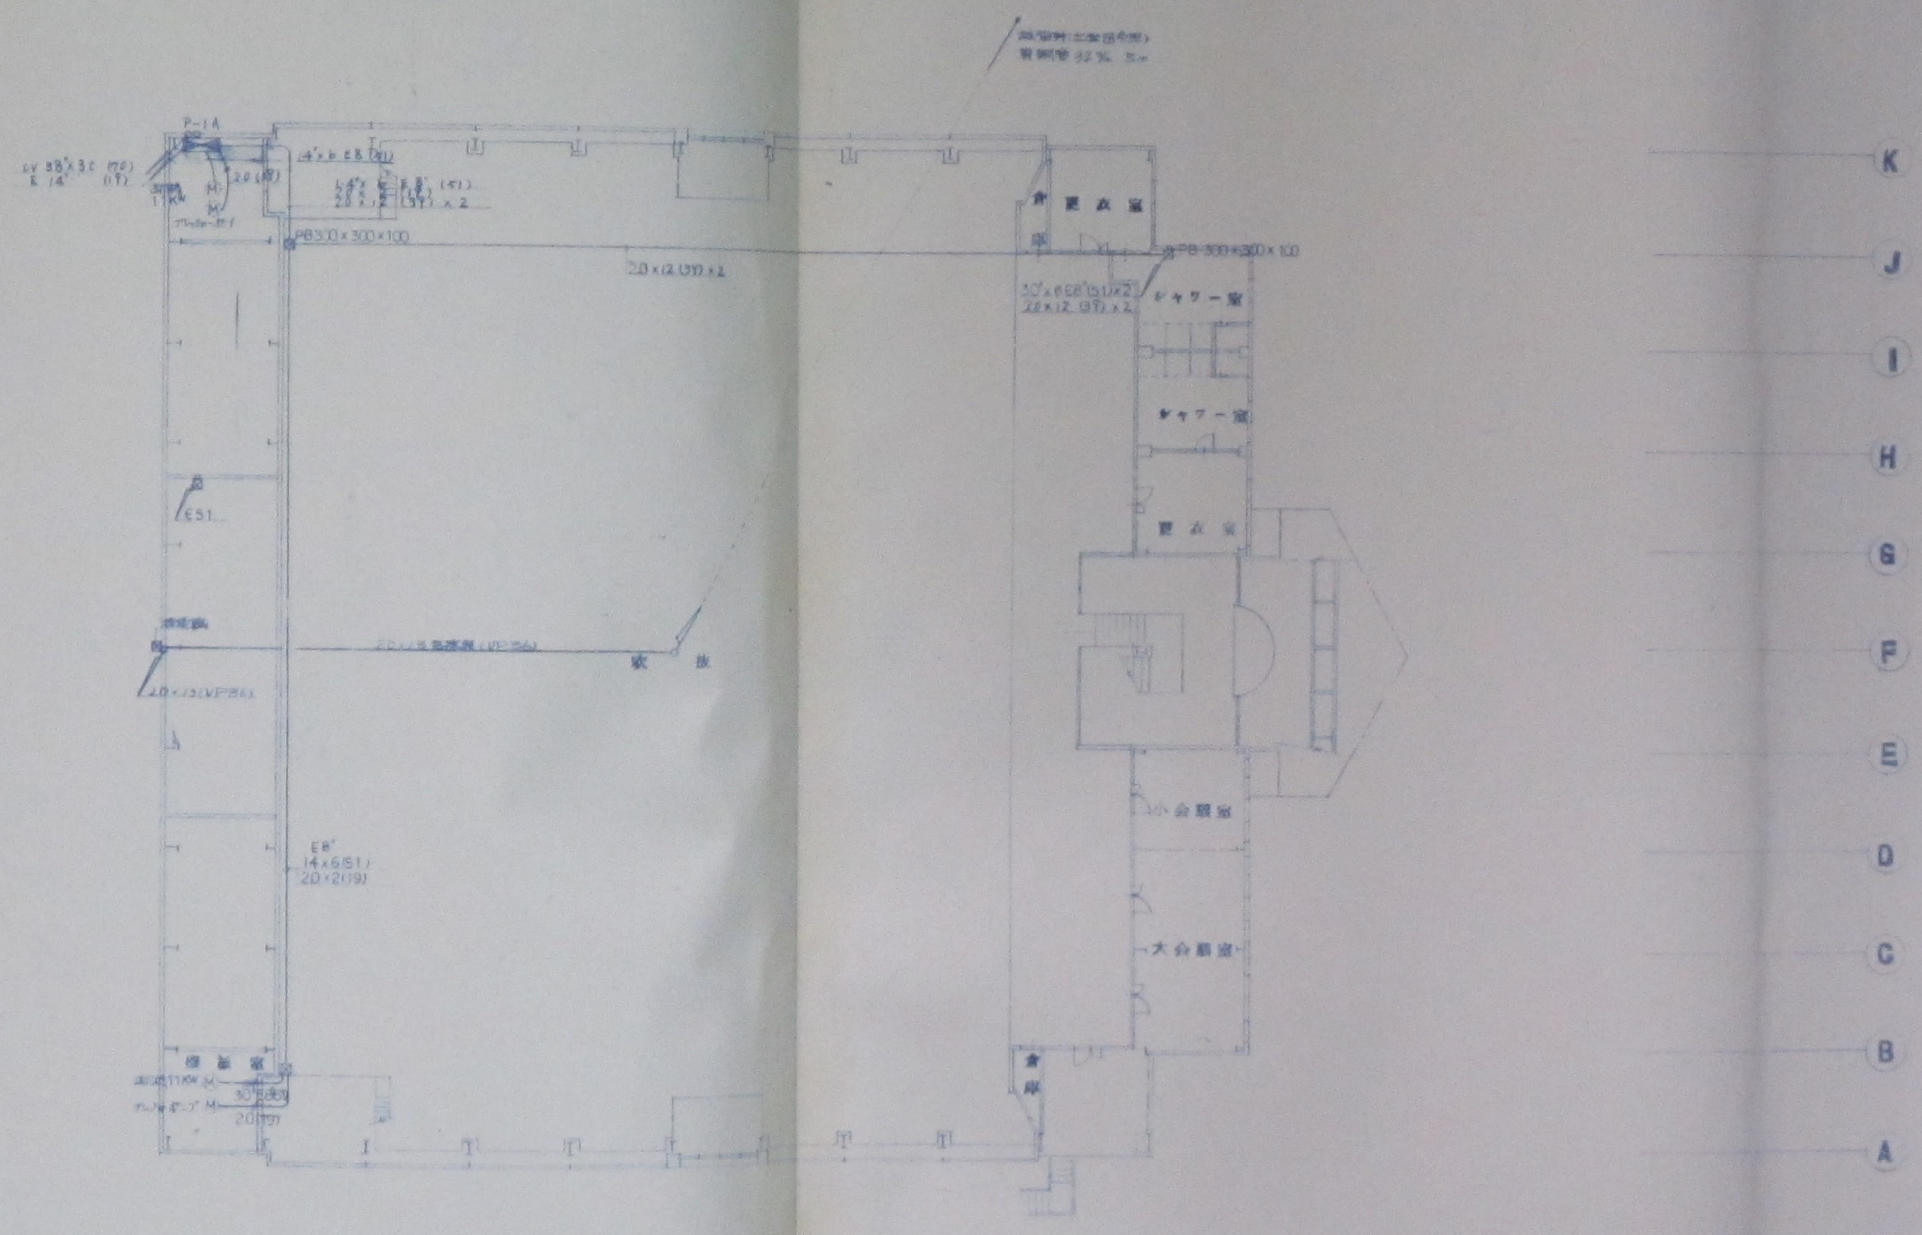


2 階客室動力機配置図 SCALE 1/100


特記事項

設計名称	設計番号
石町民体育館新築工事	


図面名称	図面番号
2 階客室動力機配置図	

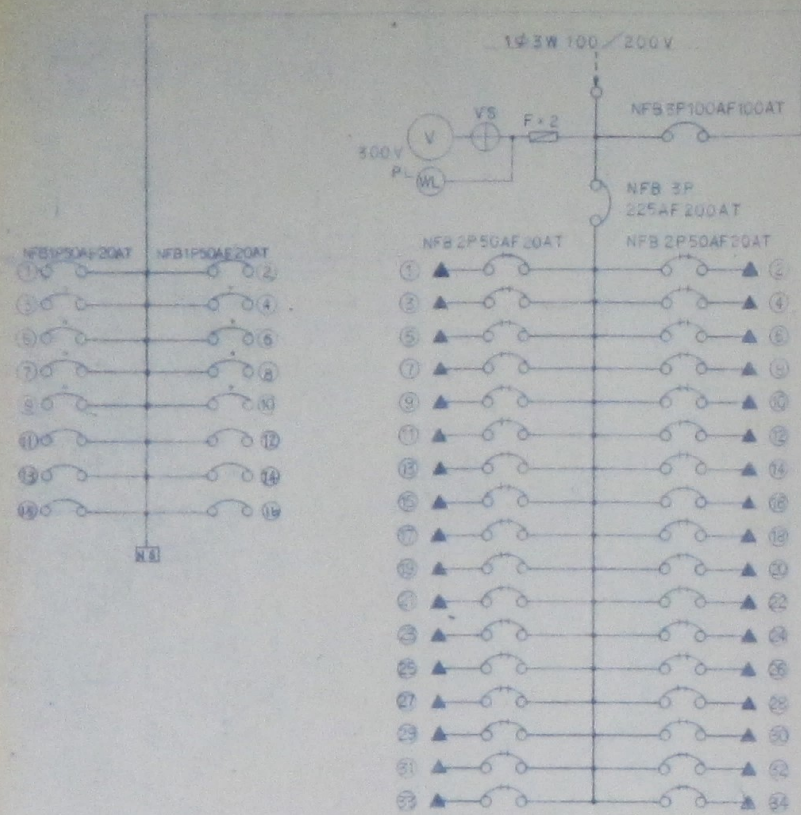


L-1 分電盤

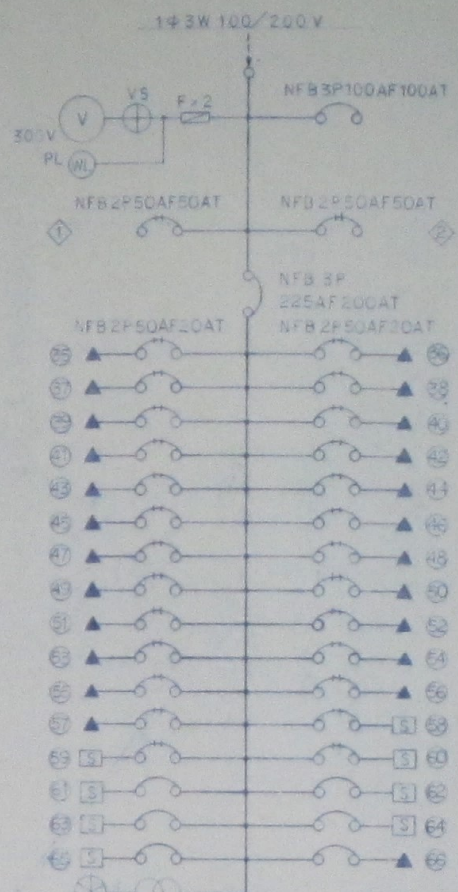


南東スイッチ
(カーテンモーター)

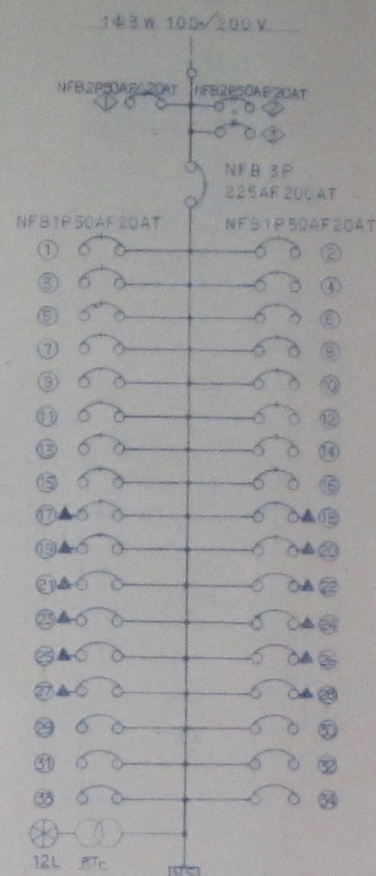

L-2 分電盤

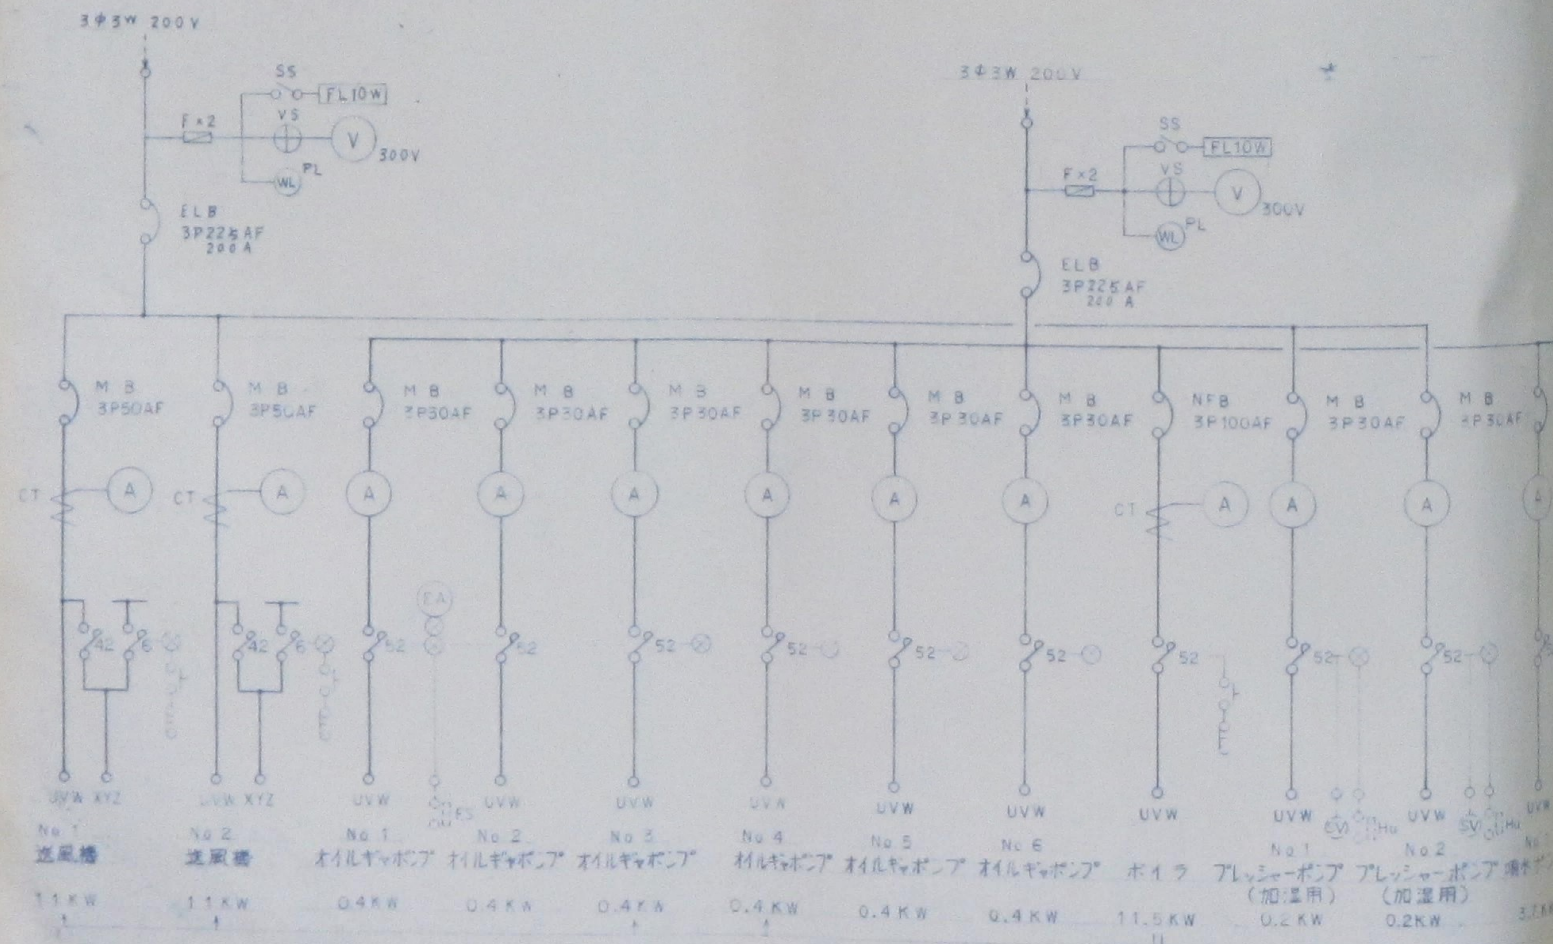


P-1A 制御盤

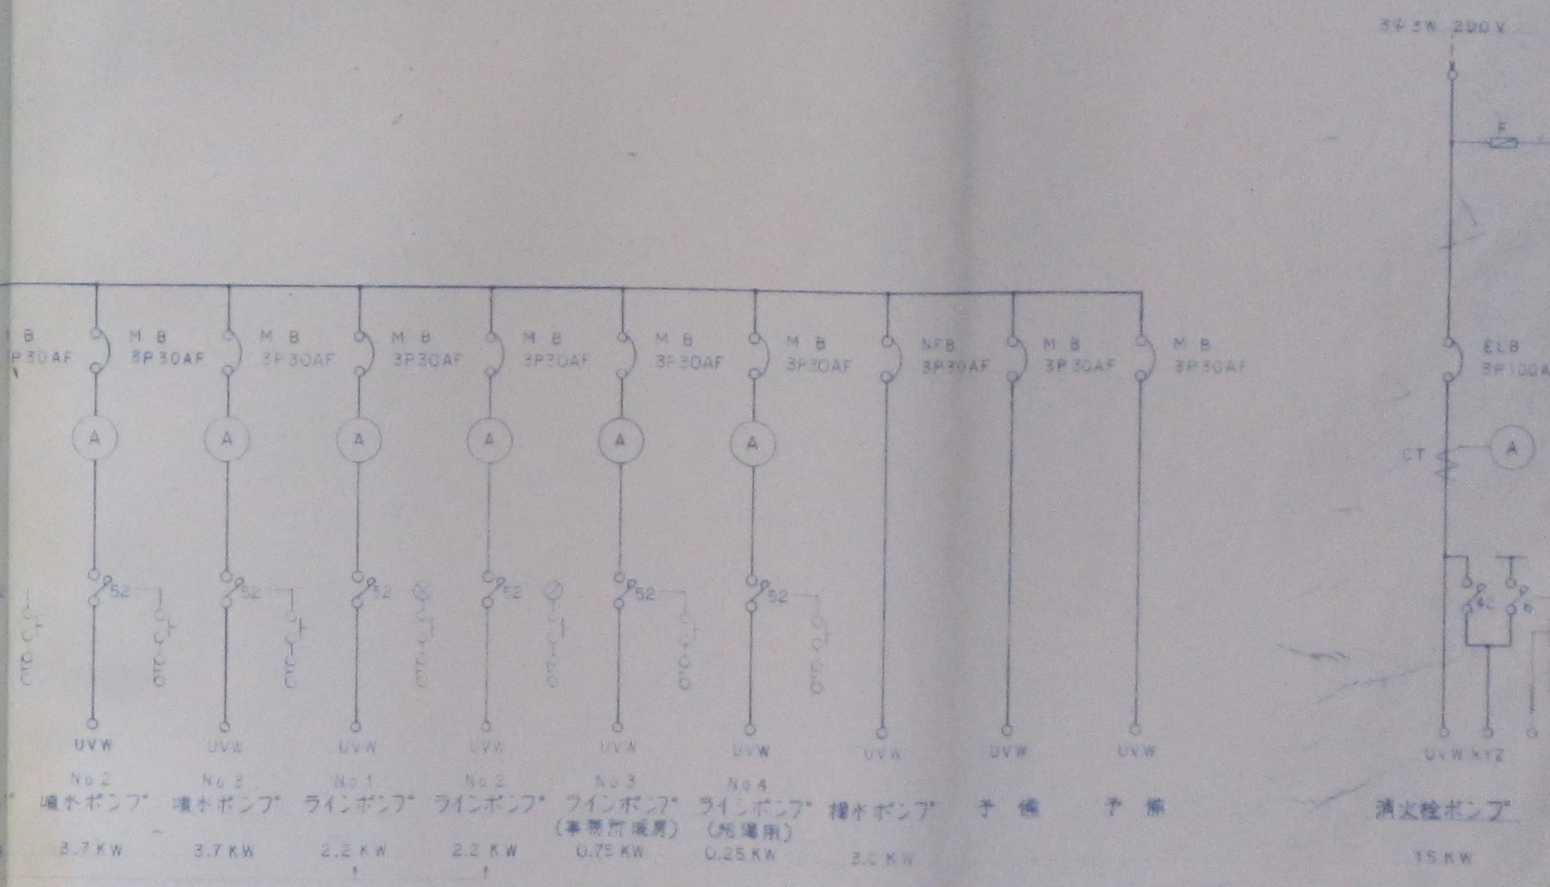

P-2 操作盤

特記事項				設計名称 百石町民体育館新築工事				設計番号				図面名称 電気設備図				
基	部長	担当	設計	製図	昭和	年	月	日	縮尺	図番	巻	頁	頁数	図番	巻	頁

1 2 3 4 5 6 7 8 9 10 11 12

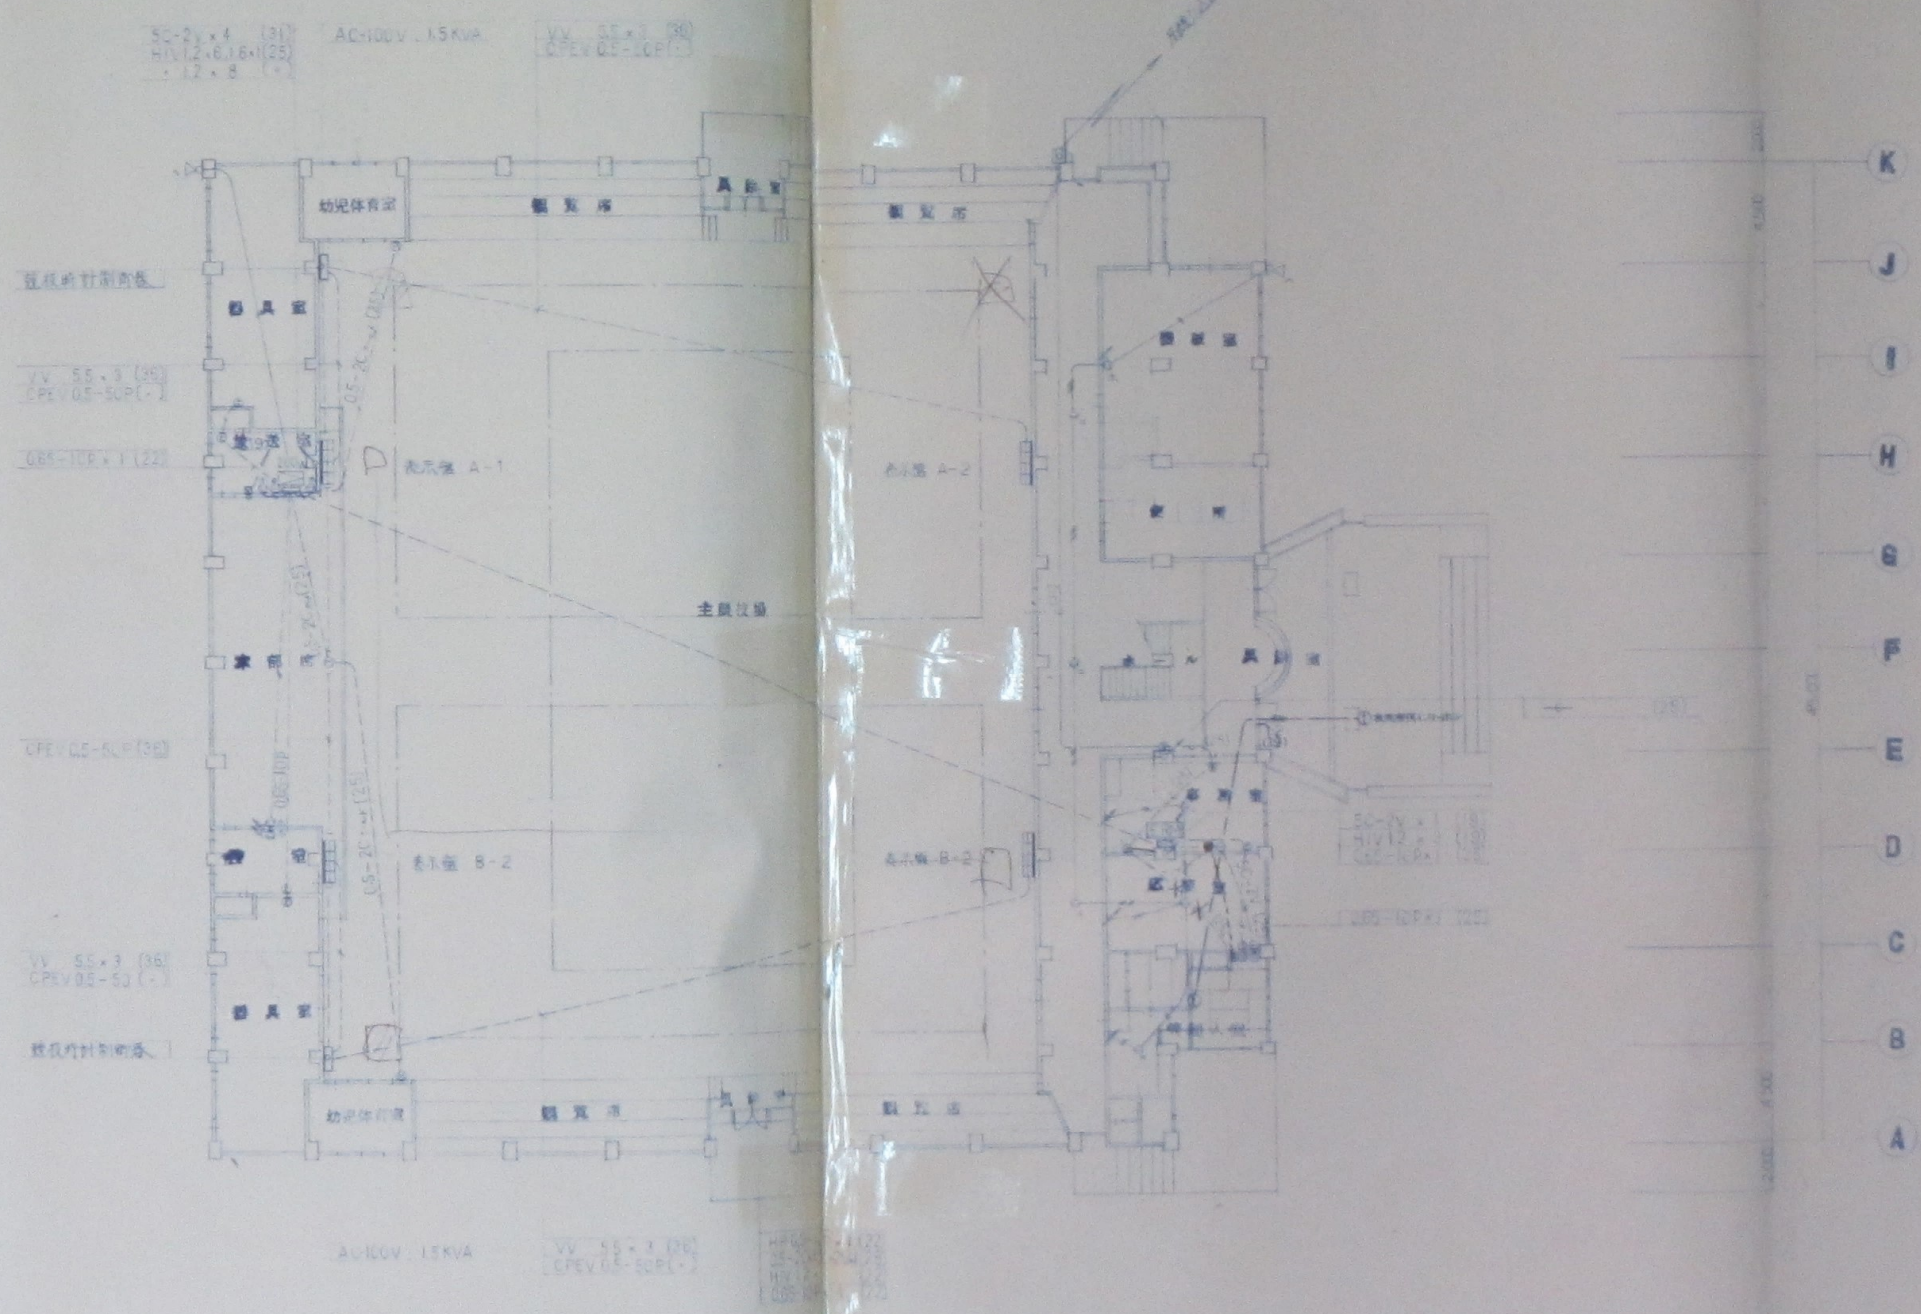

1:1 本圖之尺寸均按圖中尺寸為準(2019.12)

1 附圖之尺寸均按圖中尺寸為準(2019.12)

特記事項

計畫名稱
 臺南市立體育館新館工程

設計者

圖面名稱

1 附圖之尺寸均按圖中尺寸為準

1352046127

Figure 1

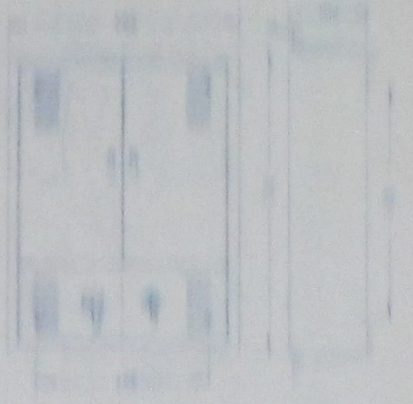


Figure 2

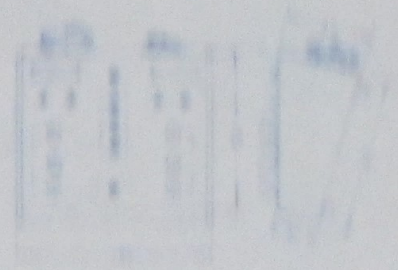


Figure 3

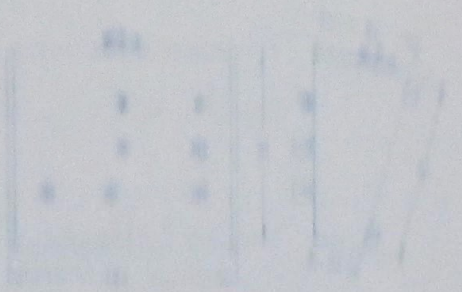


Figure 4

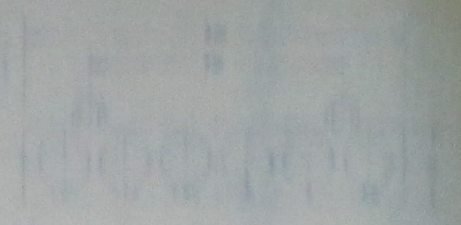


Figure 5

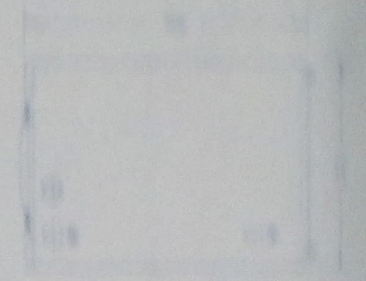


Figure 6

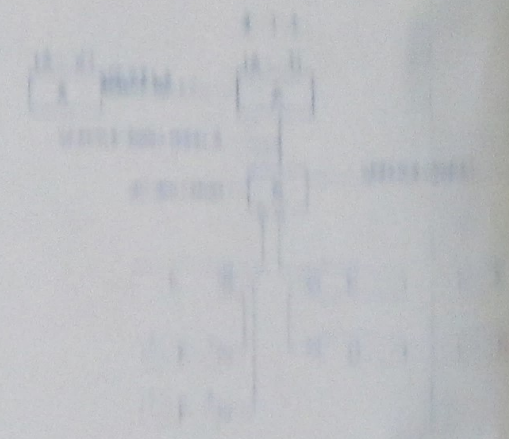


Figure 7

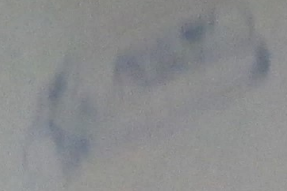


Figure 8

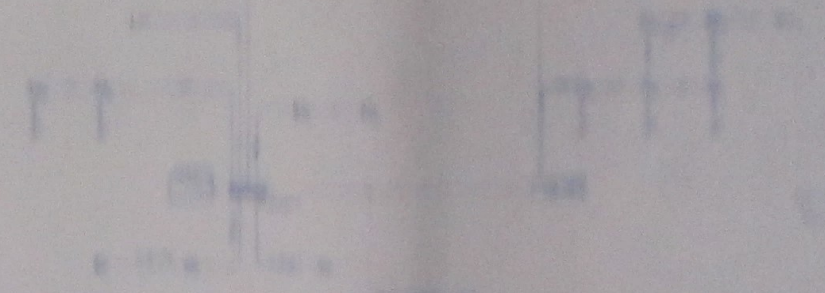
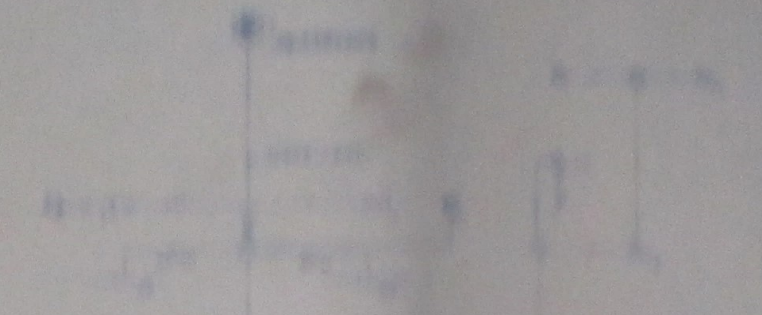


Figure 9



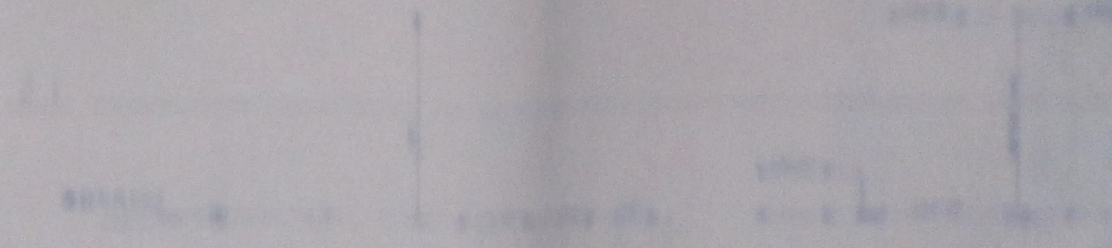


Figure 10

 

1	2	3	4	5	6	7	8	9	10	11	12	13	14	15	16	17	18	19	20	21	22	23	24	25	26	27	28	29	30	31	32	33	34	35	36	37	38	39	40	41	42	43	44	45	46	47	48	49	50
---	---	---	---	---	---	---	---	---	----	----	
1 2 3 4 5 6 7 8 9 10 11 12

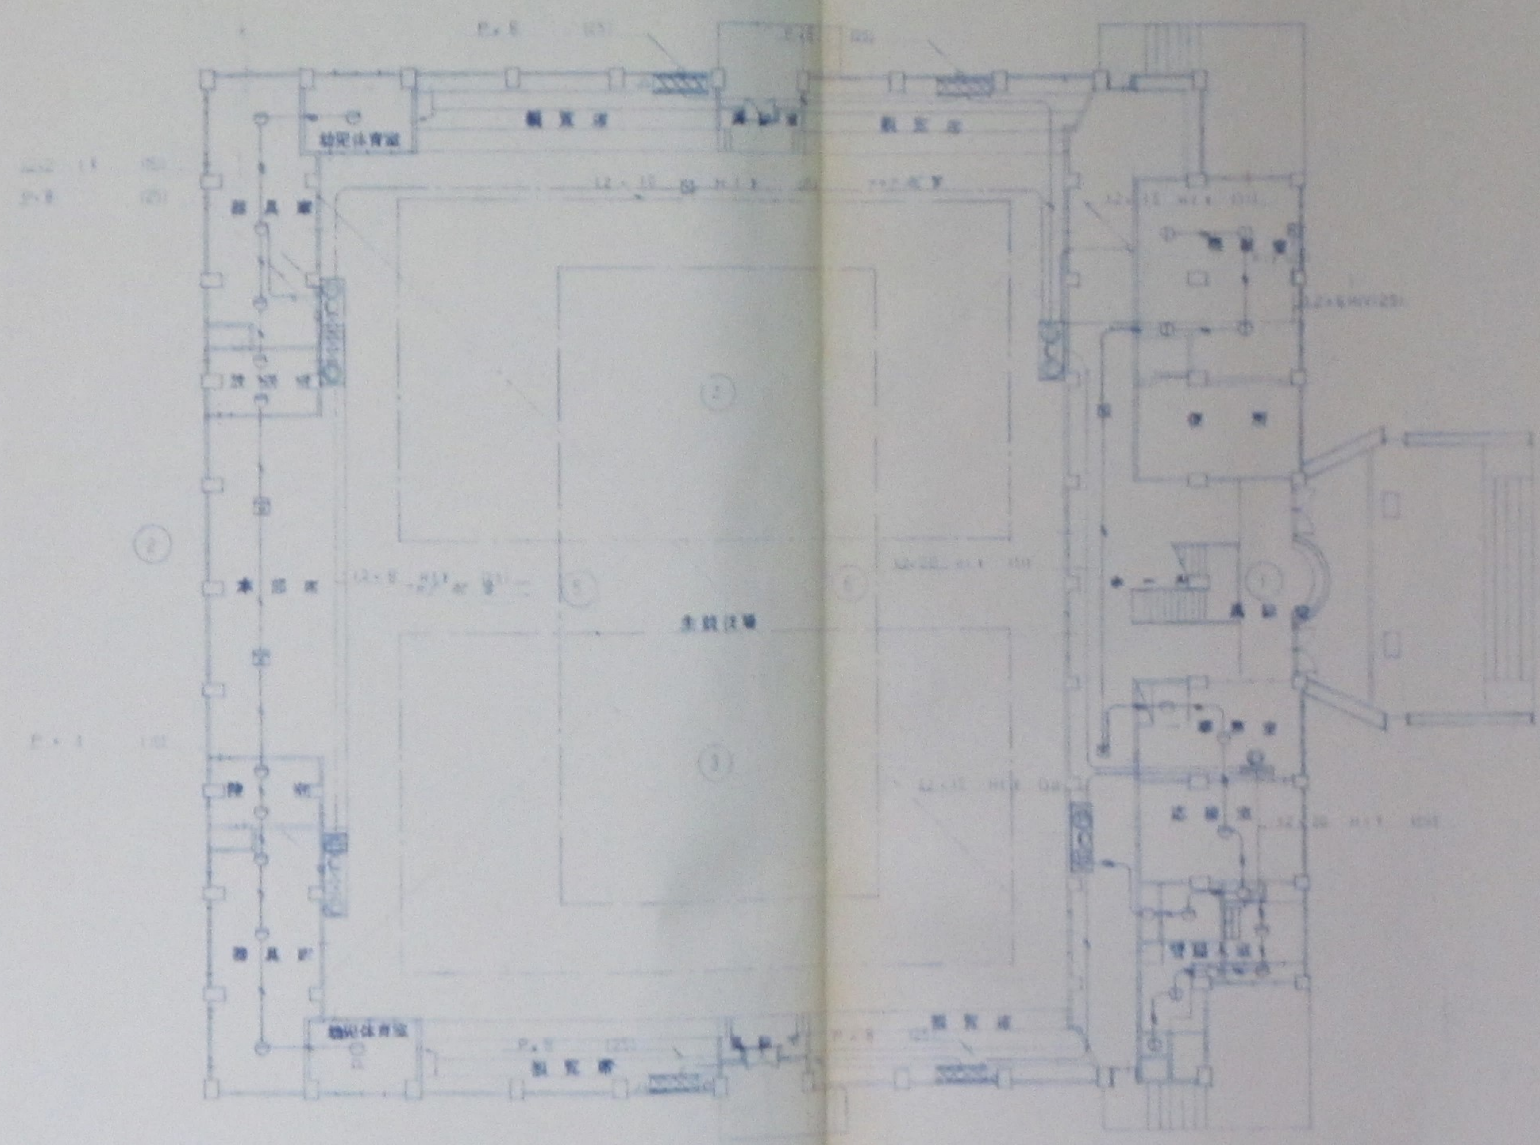




图一 大会堂平面布置图

图例


设计名称 黄石市人民体育馆新馆工程

设计单位


设计日期

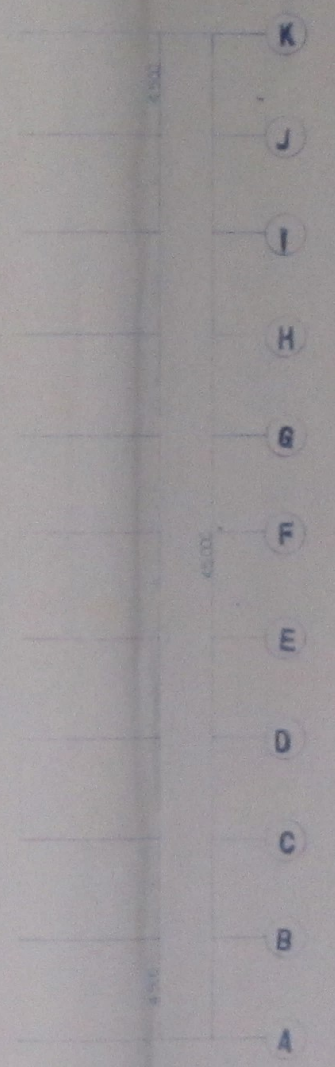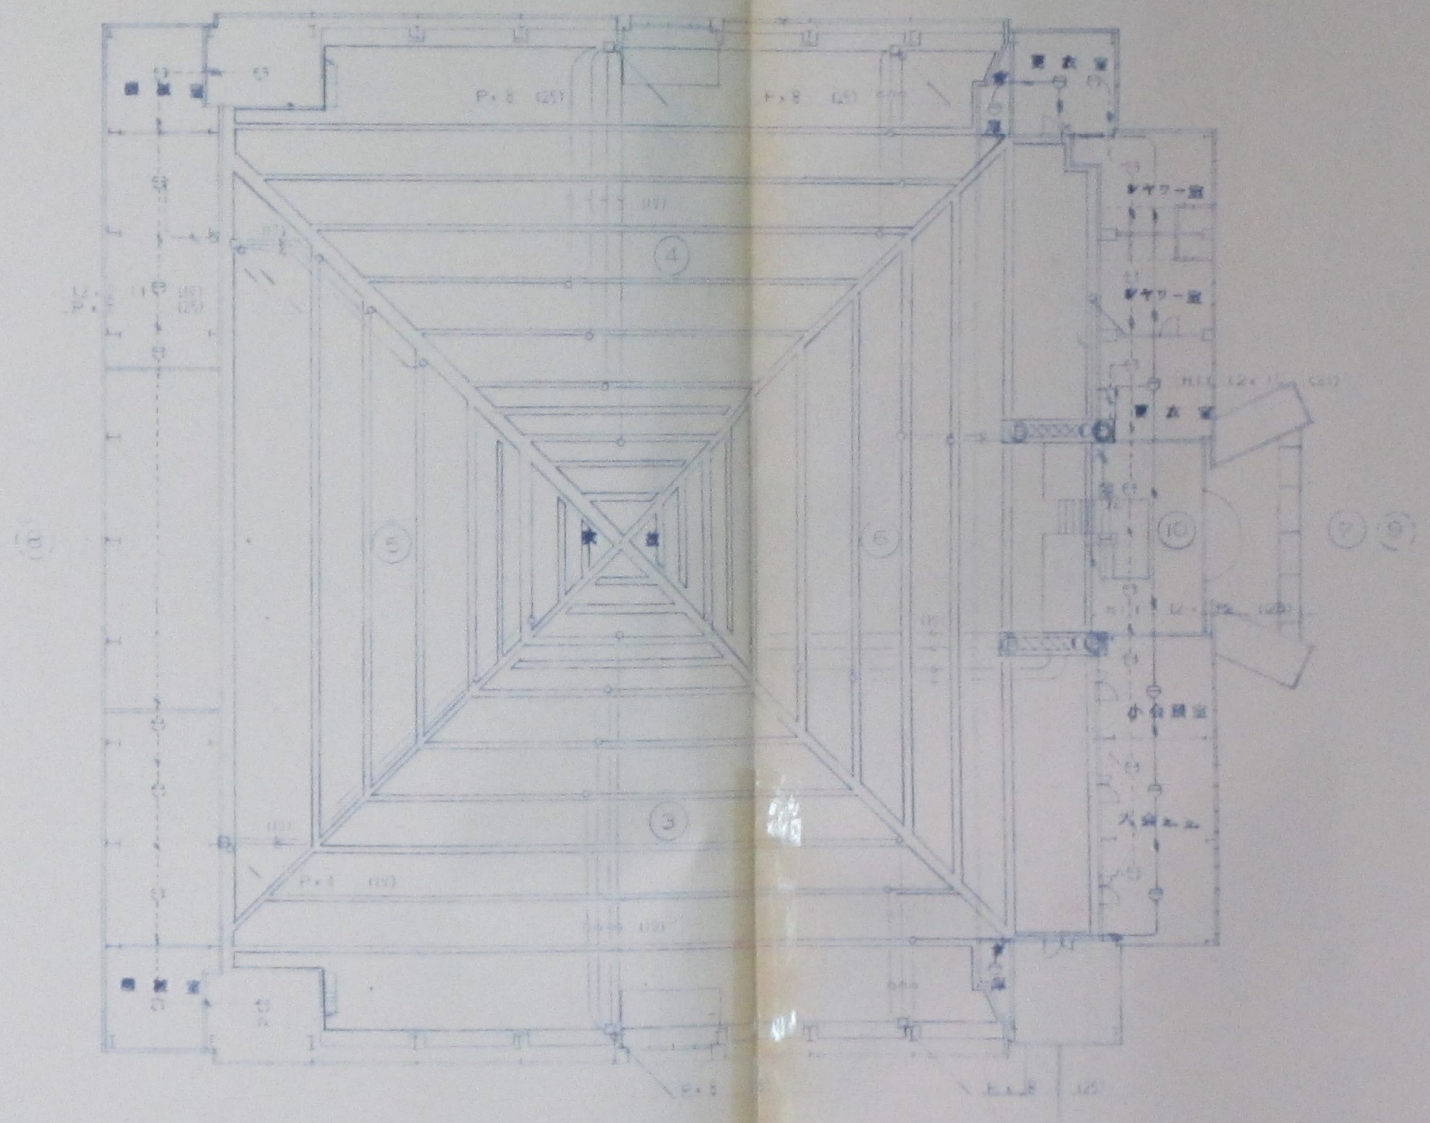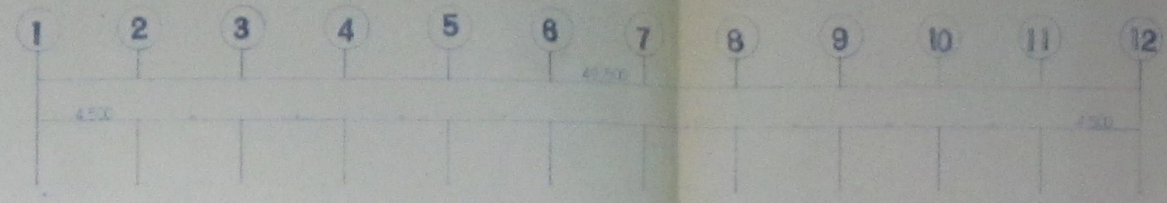


1-2 樓火災探測配線圖 [圖號: 1-2]

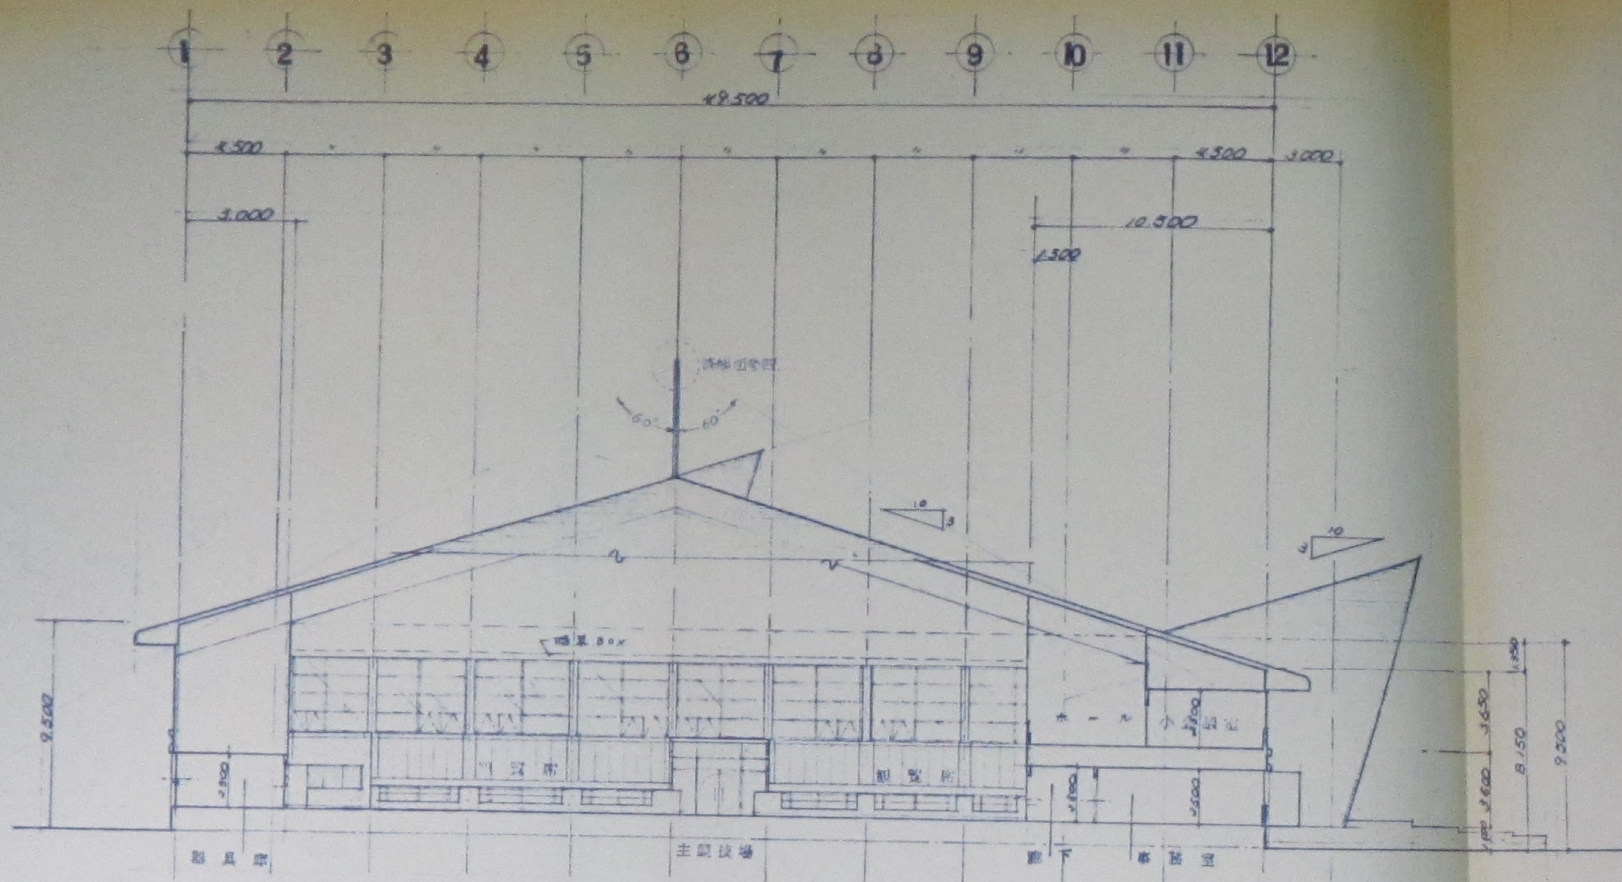


1-12 断面图 SCALE 1:100

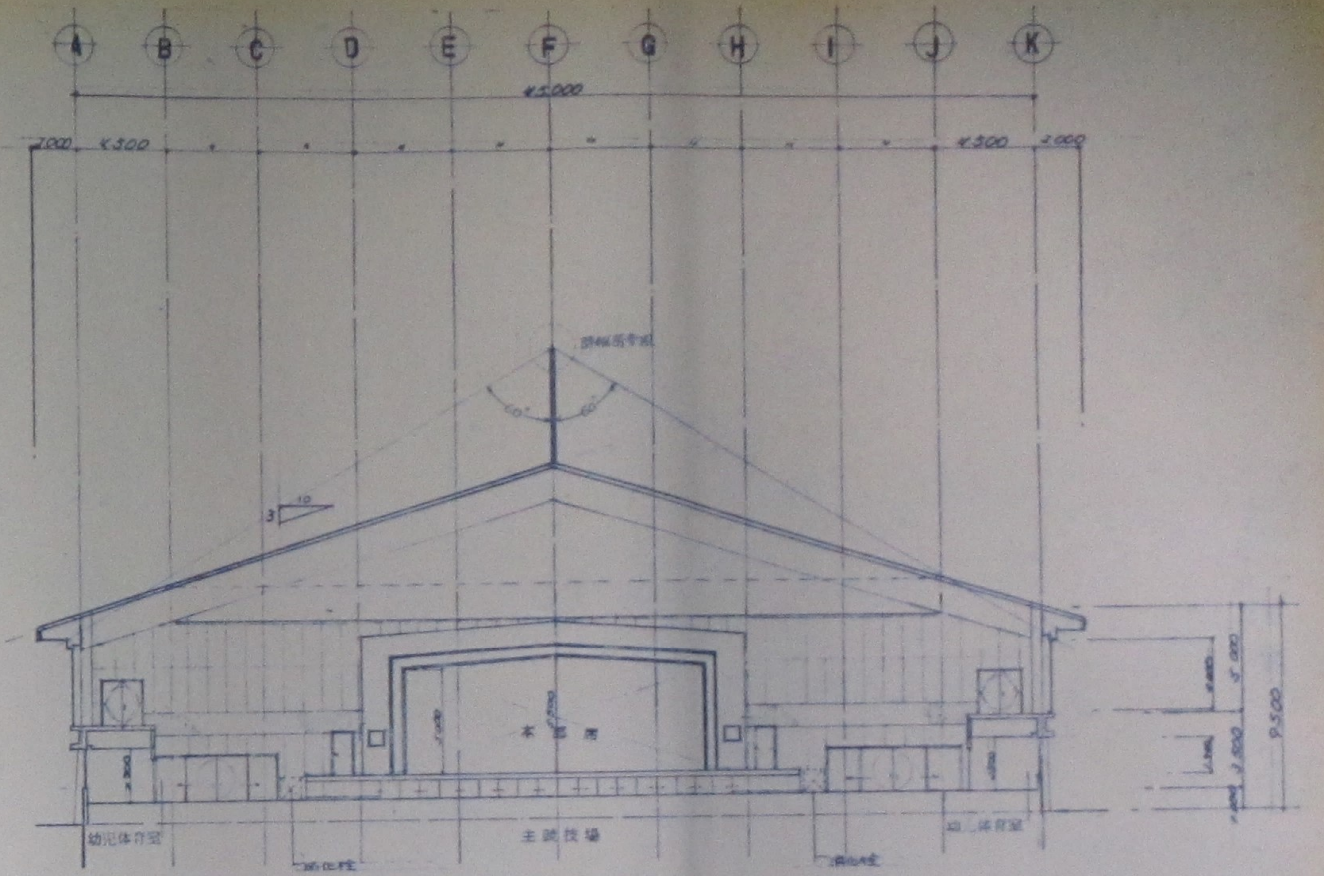

A-K 断面图 SCALE 1:100

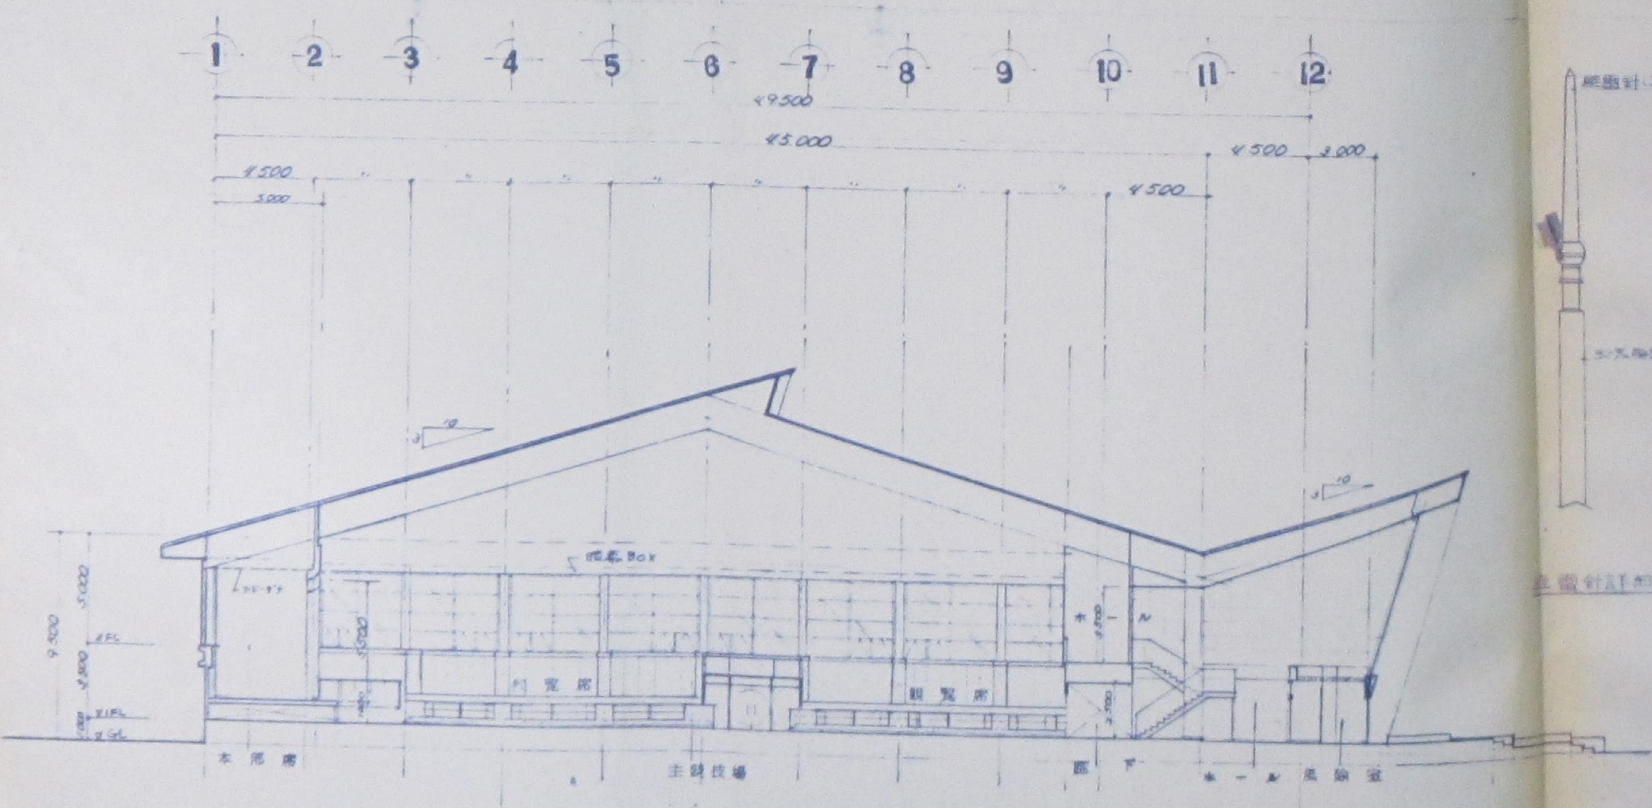

1-12 断面图 SCALE 1:100

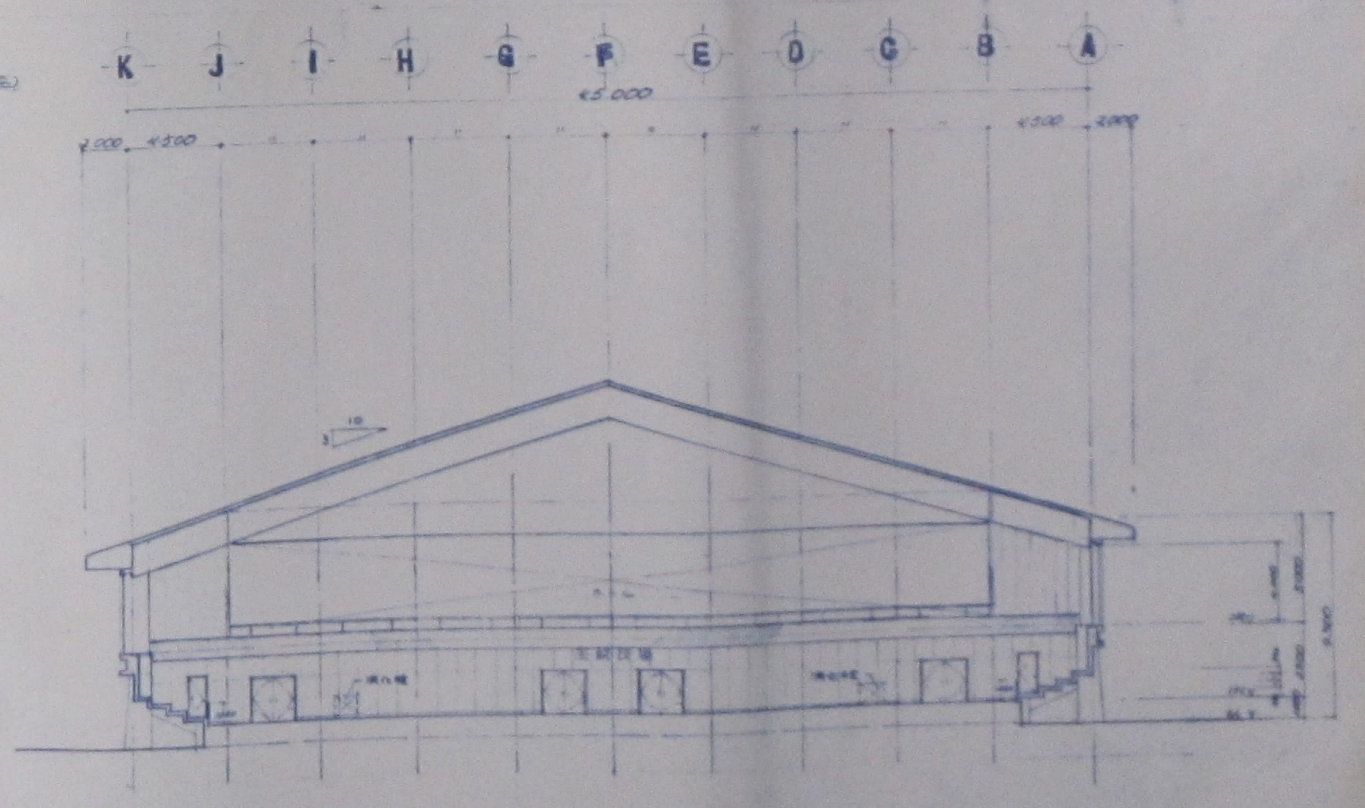

A-K 断面图 SCALE 1:100